

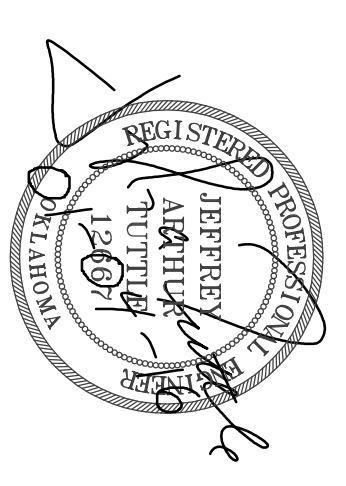



PUBLIC SERVICE CO. OF OKLAHOMA - 580-1511  
 OKLAHOMA NATURAL GAS CO - 832-7800  
 GTE - 665-8900  
 TULSA CABLE TELEVISION - 665-0200

BEFORE YOU DIG .... CALL OKIE 1-800-522-6543


DATE	REVISIONS	CITY OF BROKEN ARROW Where opportunity lives		DRAINAGE PLAN THE VILLAS AT BEL LAGO CITY OF BROKEN ARROW		TUTTLE & ASSOCIATES, INC. 9714 E. 55TH PL. TULSA, OK. 74146 918-663-5567		SCALE: 1"=100'		DESIGN DATE		DRAFTED DATE	
								HORIZ. 1"=100'		DATE		DATE	
								VERT. 1"=100'		DATE		DATE	
								DRAWING NAME: DRAINAGE PLAN		SHEET 4		PROJECT NO.	
								PROPOSED PLAN		OF 7			

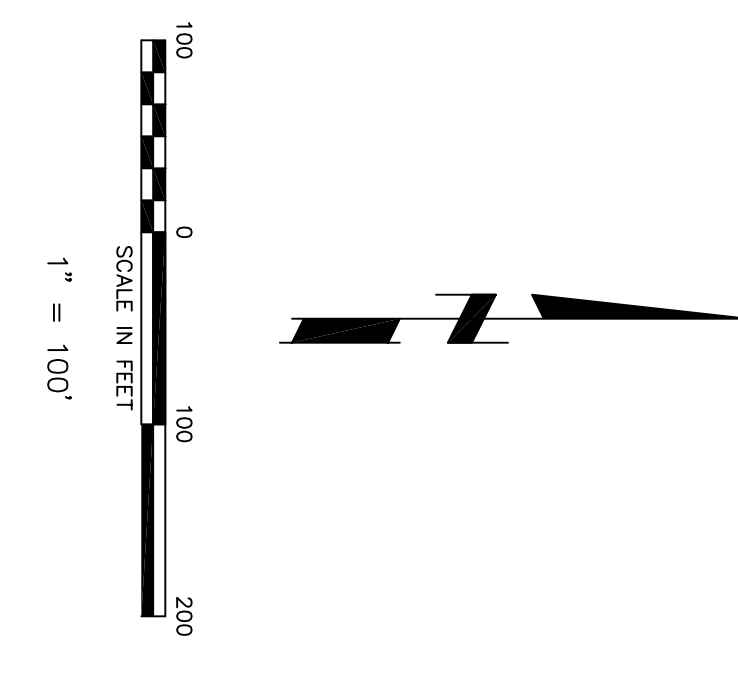




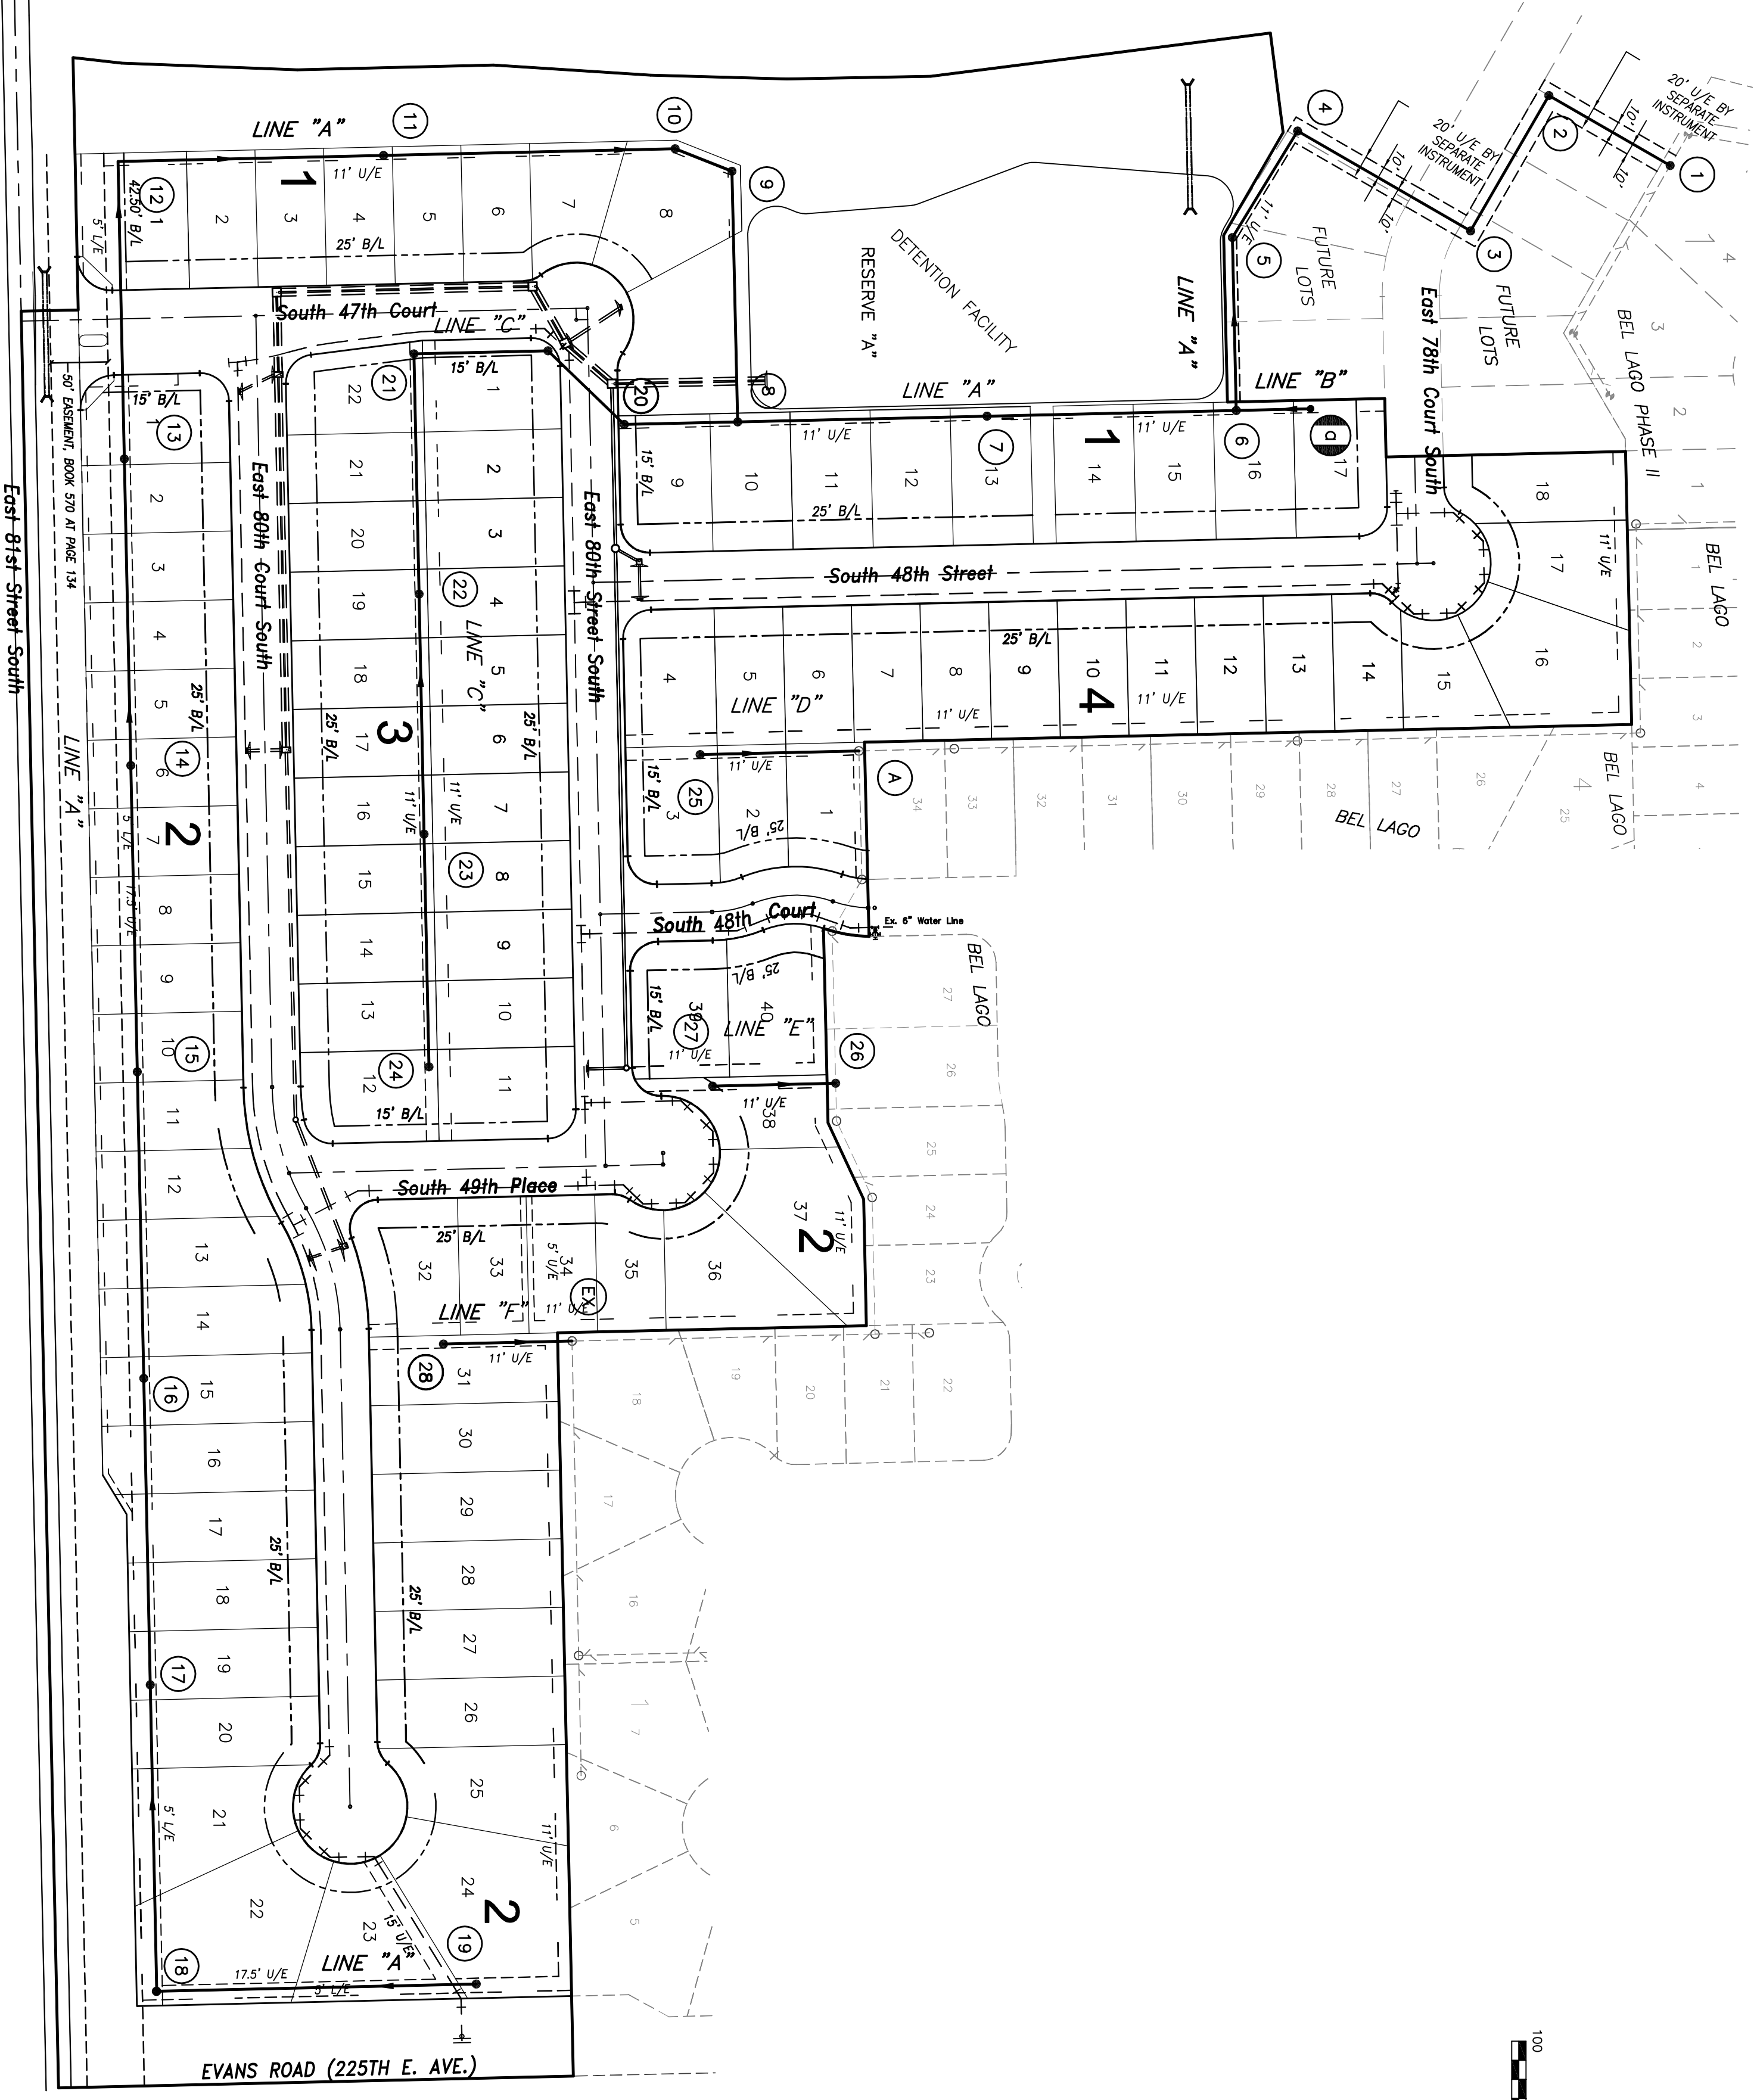



  
 PUBLIC SERVICE CO. OF OKLAHOMA - 850-1511  
 OKLAHOMA NATURAL GAS CO. - 832-7800  
 GTE - 865-8900  
 TULSA CABLE TELEVISION - 865-0200

BEFORE YOU DIG .... CALL OKIE 1-800-522-6543

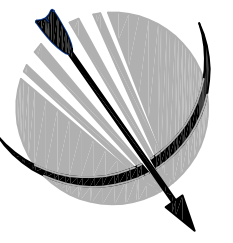DATE	REVISIONS	 <b>CITY OF BROKEN ARROW</b> Where opportunity lives	<b>SANITARY SEWER PLANS</b> THE VILLAS AT BEL LAGO CITY OF BROKEN ARROW	<b>TUTTLE &amp; ASSOCIATES, INC.</b> 9714 E. 55TH PL. TULSA, OK. 74146 918-663-5567	SCALE: 1"=100'	DESIGN DATE	DRAFTED DATE
					HORIZ. 1"=100'	REVIEWED DATE	APPROVED DATE
			DRAWING NAME: SANITARY SEWER PLAN	SHEET 4 OF 7	PROJECT NO.		

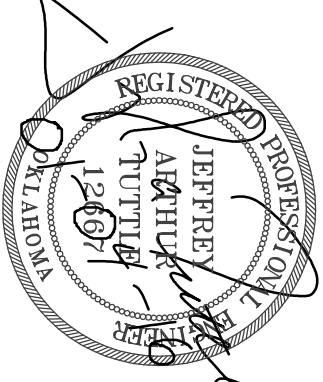
  
 REGISTERED PROFESSIONAL ENGINEER  
 JEFFREY ARTHUR TUTTLE  
 1207  
 OKLAHOMA

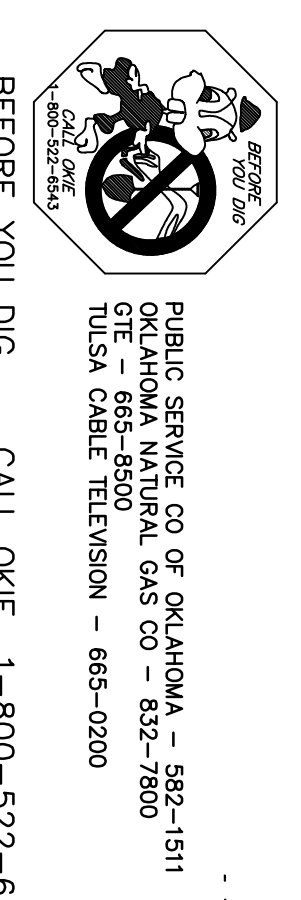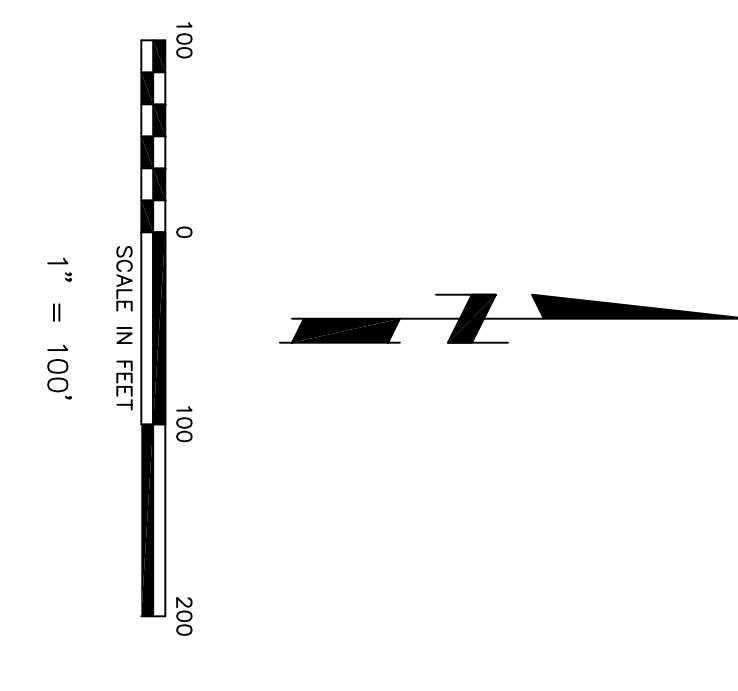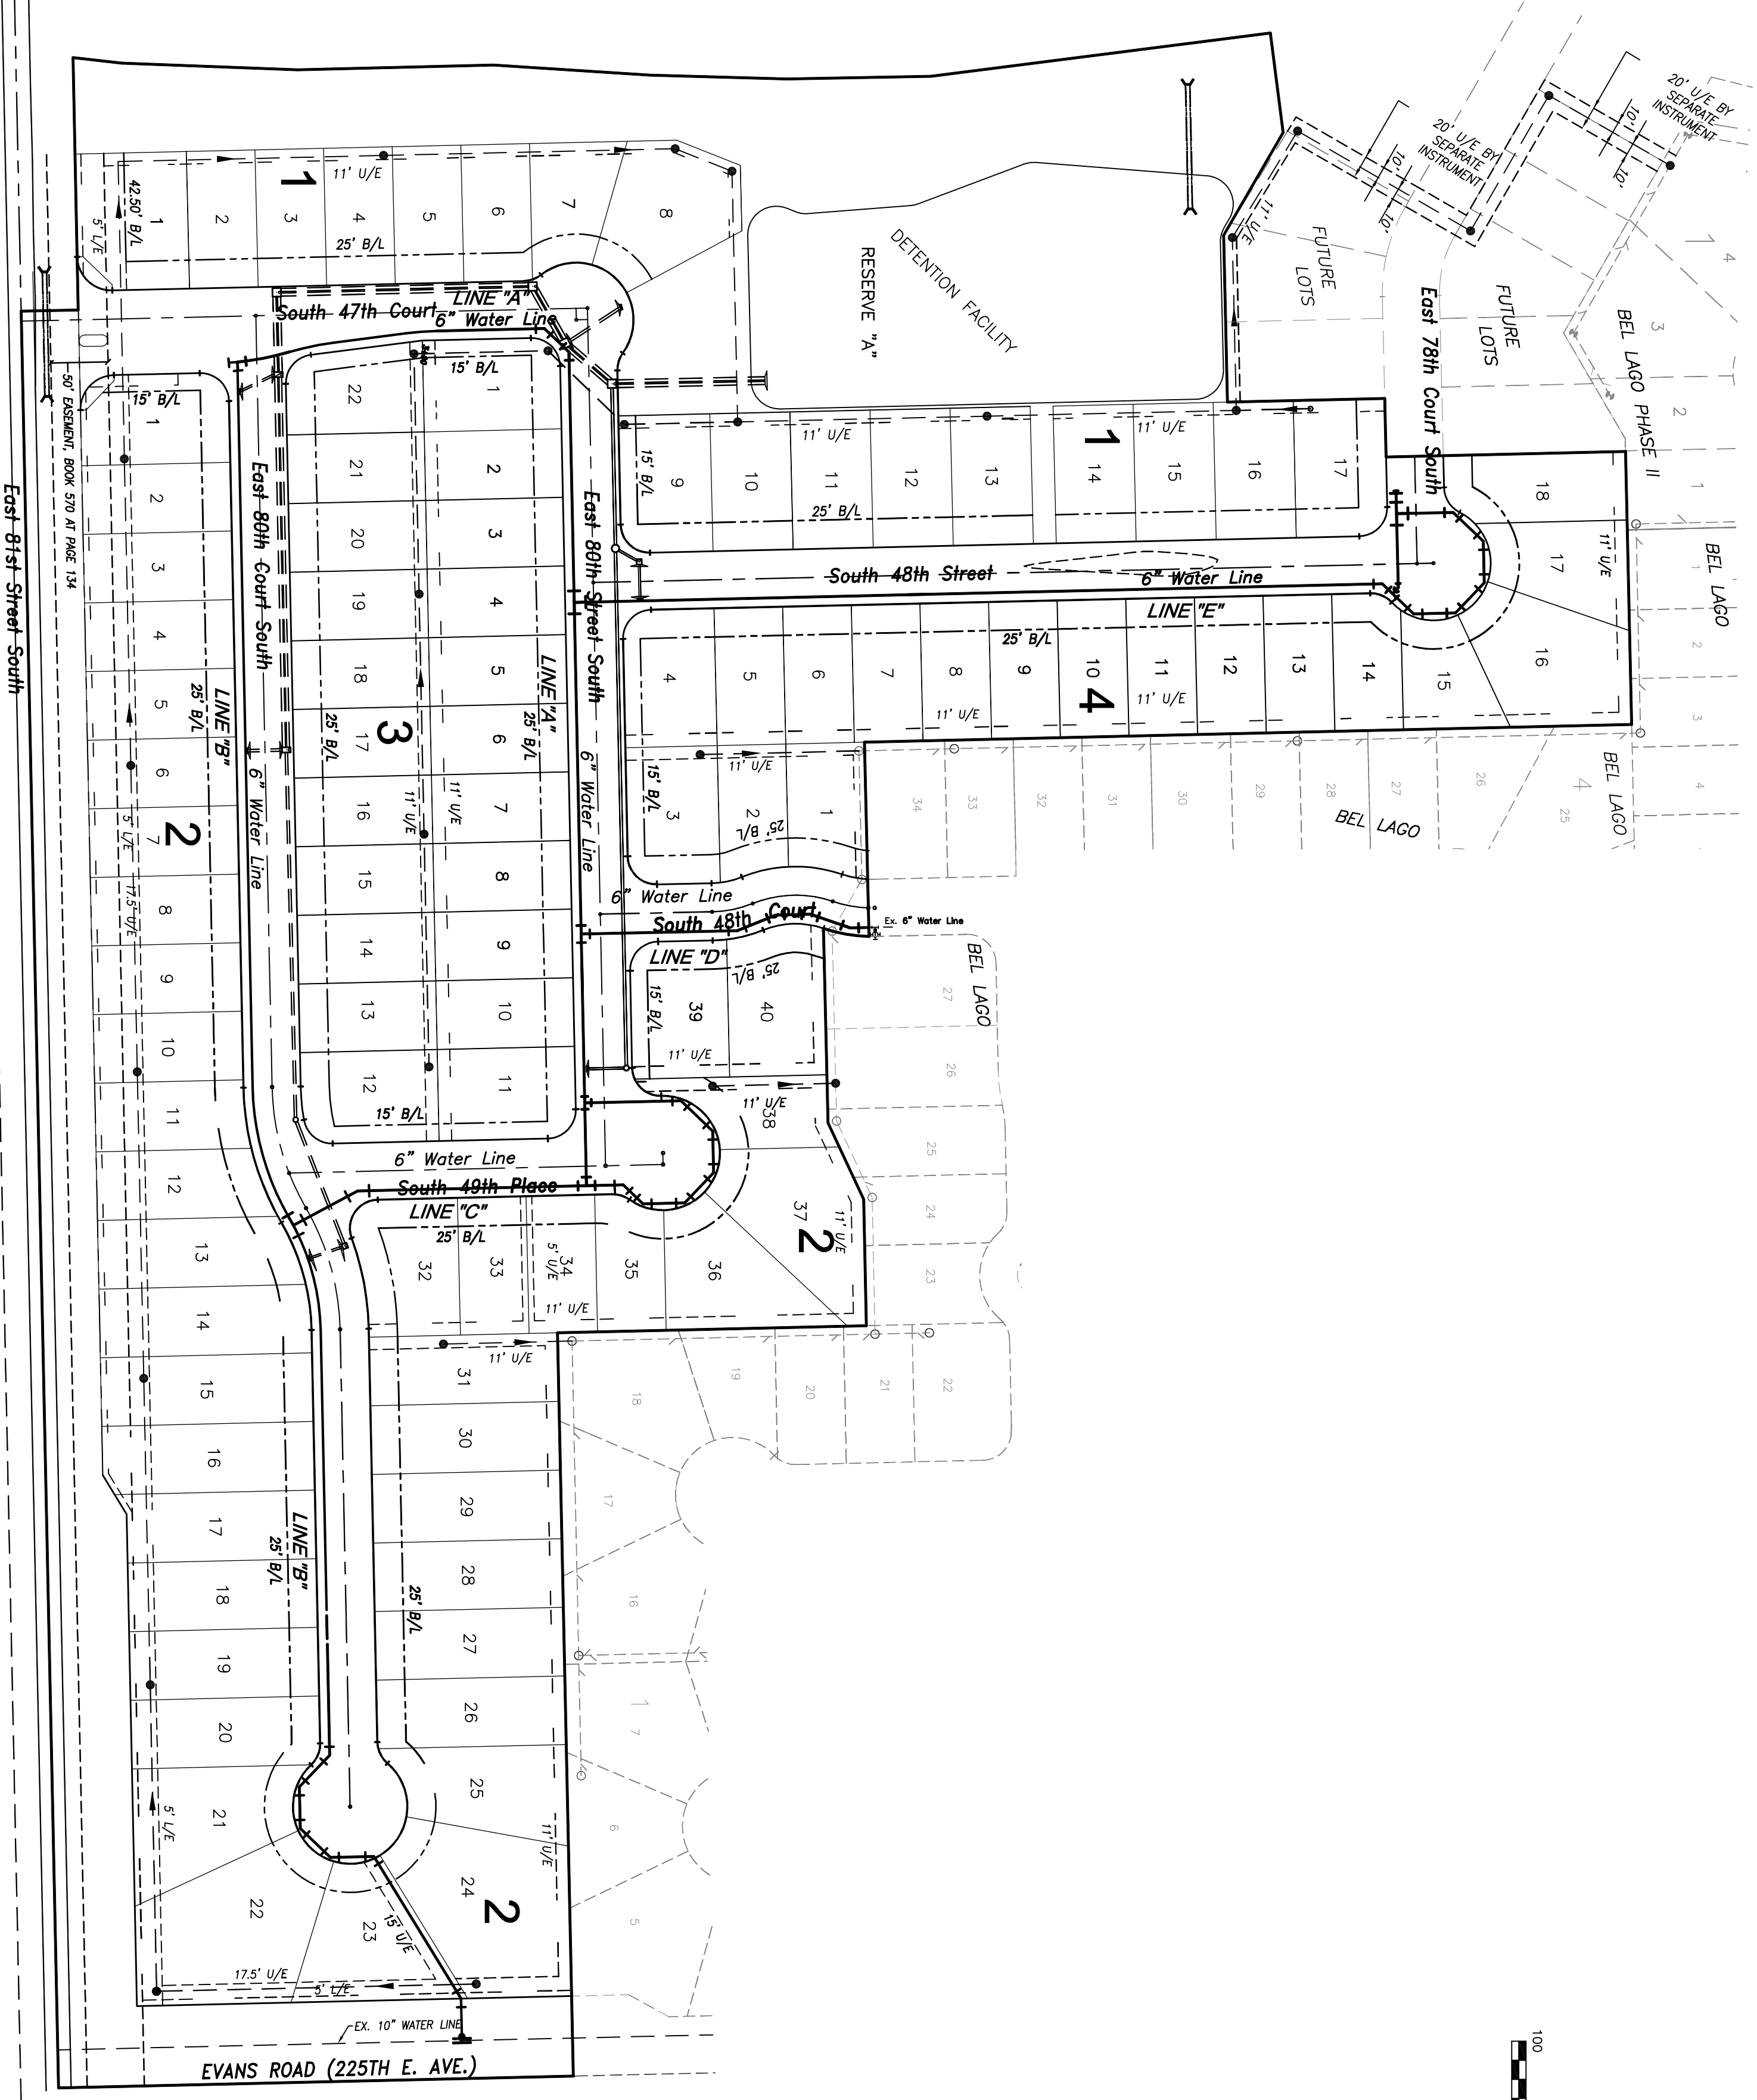

BEFORE YOU DIG .... CALL OKIE 1-800-522-6543

PUBLIC SERVICE CO. OF OKLAHOMA - 580-1511  
 OKLAHOMA NATURAL GAS CO. - 832-7800  
 GTE - 665-8900  
 TULSA CABLE TELEVISION - 665-0200

DATE	REVISIONS	 <b>CITY OF BROKEN ARROW</b> Where opportunity lives	<b>WATER PLANS</b> THE VILLAS AT BEL LAGO CITY OF BROKEN ARROW	<b>TUTTLE &amp; ASSOCIATES, INC.</b> 9714 E. 55TH PL. TULSA, OK. 74146 918-663-5567	SCALE: HORIZ. 1"=100'	DESIGN DATE	DRAFTED DATE
					VERT. _____	REVIEWED DATE	APPROVED DATE
			DRAWING NAME: SHEET 4 OF 7	PROJECT NO.			

