


- Legend**
- EXISTING SANITARY
  - EXISTING WATER LINE
  - PROPOSED SANITARY SEWER SERVICE LINE
  - PROPOSED WATER SERVICE LINE (SEE NOTE #2)
  - PROPOSED FIRE LINE
  - CLEAN OUT
  - WATER METER
  - DOWNSPOUT CONNECTIONS

- Notes**
1. SEE SHEETS C16 & C17 FOR DOWNSPOUT LOCATION & PIPE SIZE
  2. FOR EACH 2" AND 3-1/2" SERVICE LINE, RUN THE LINE UNDER A GREEN AREA AND INSTALL 2" AND 3-1/2" BALL VALVES, WRAP LOCATOR TAPE AROUND THE VALVE AND BRING THE TAPE TO THE SURFACE AND MAKE A VALVE LOCATION MARKER ON THE ADJACENT CURB.

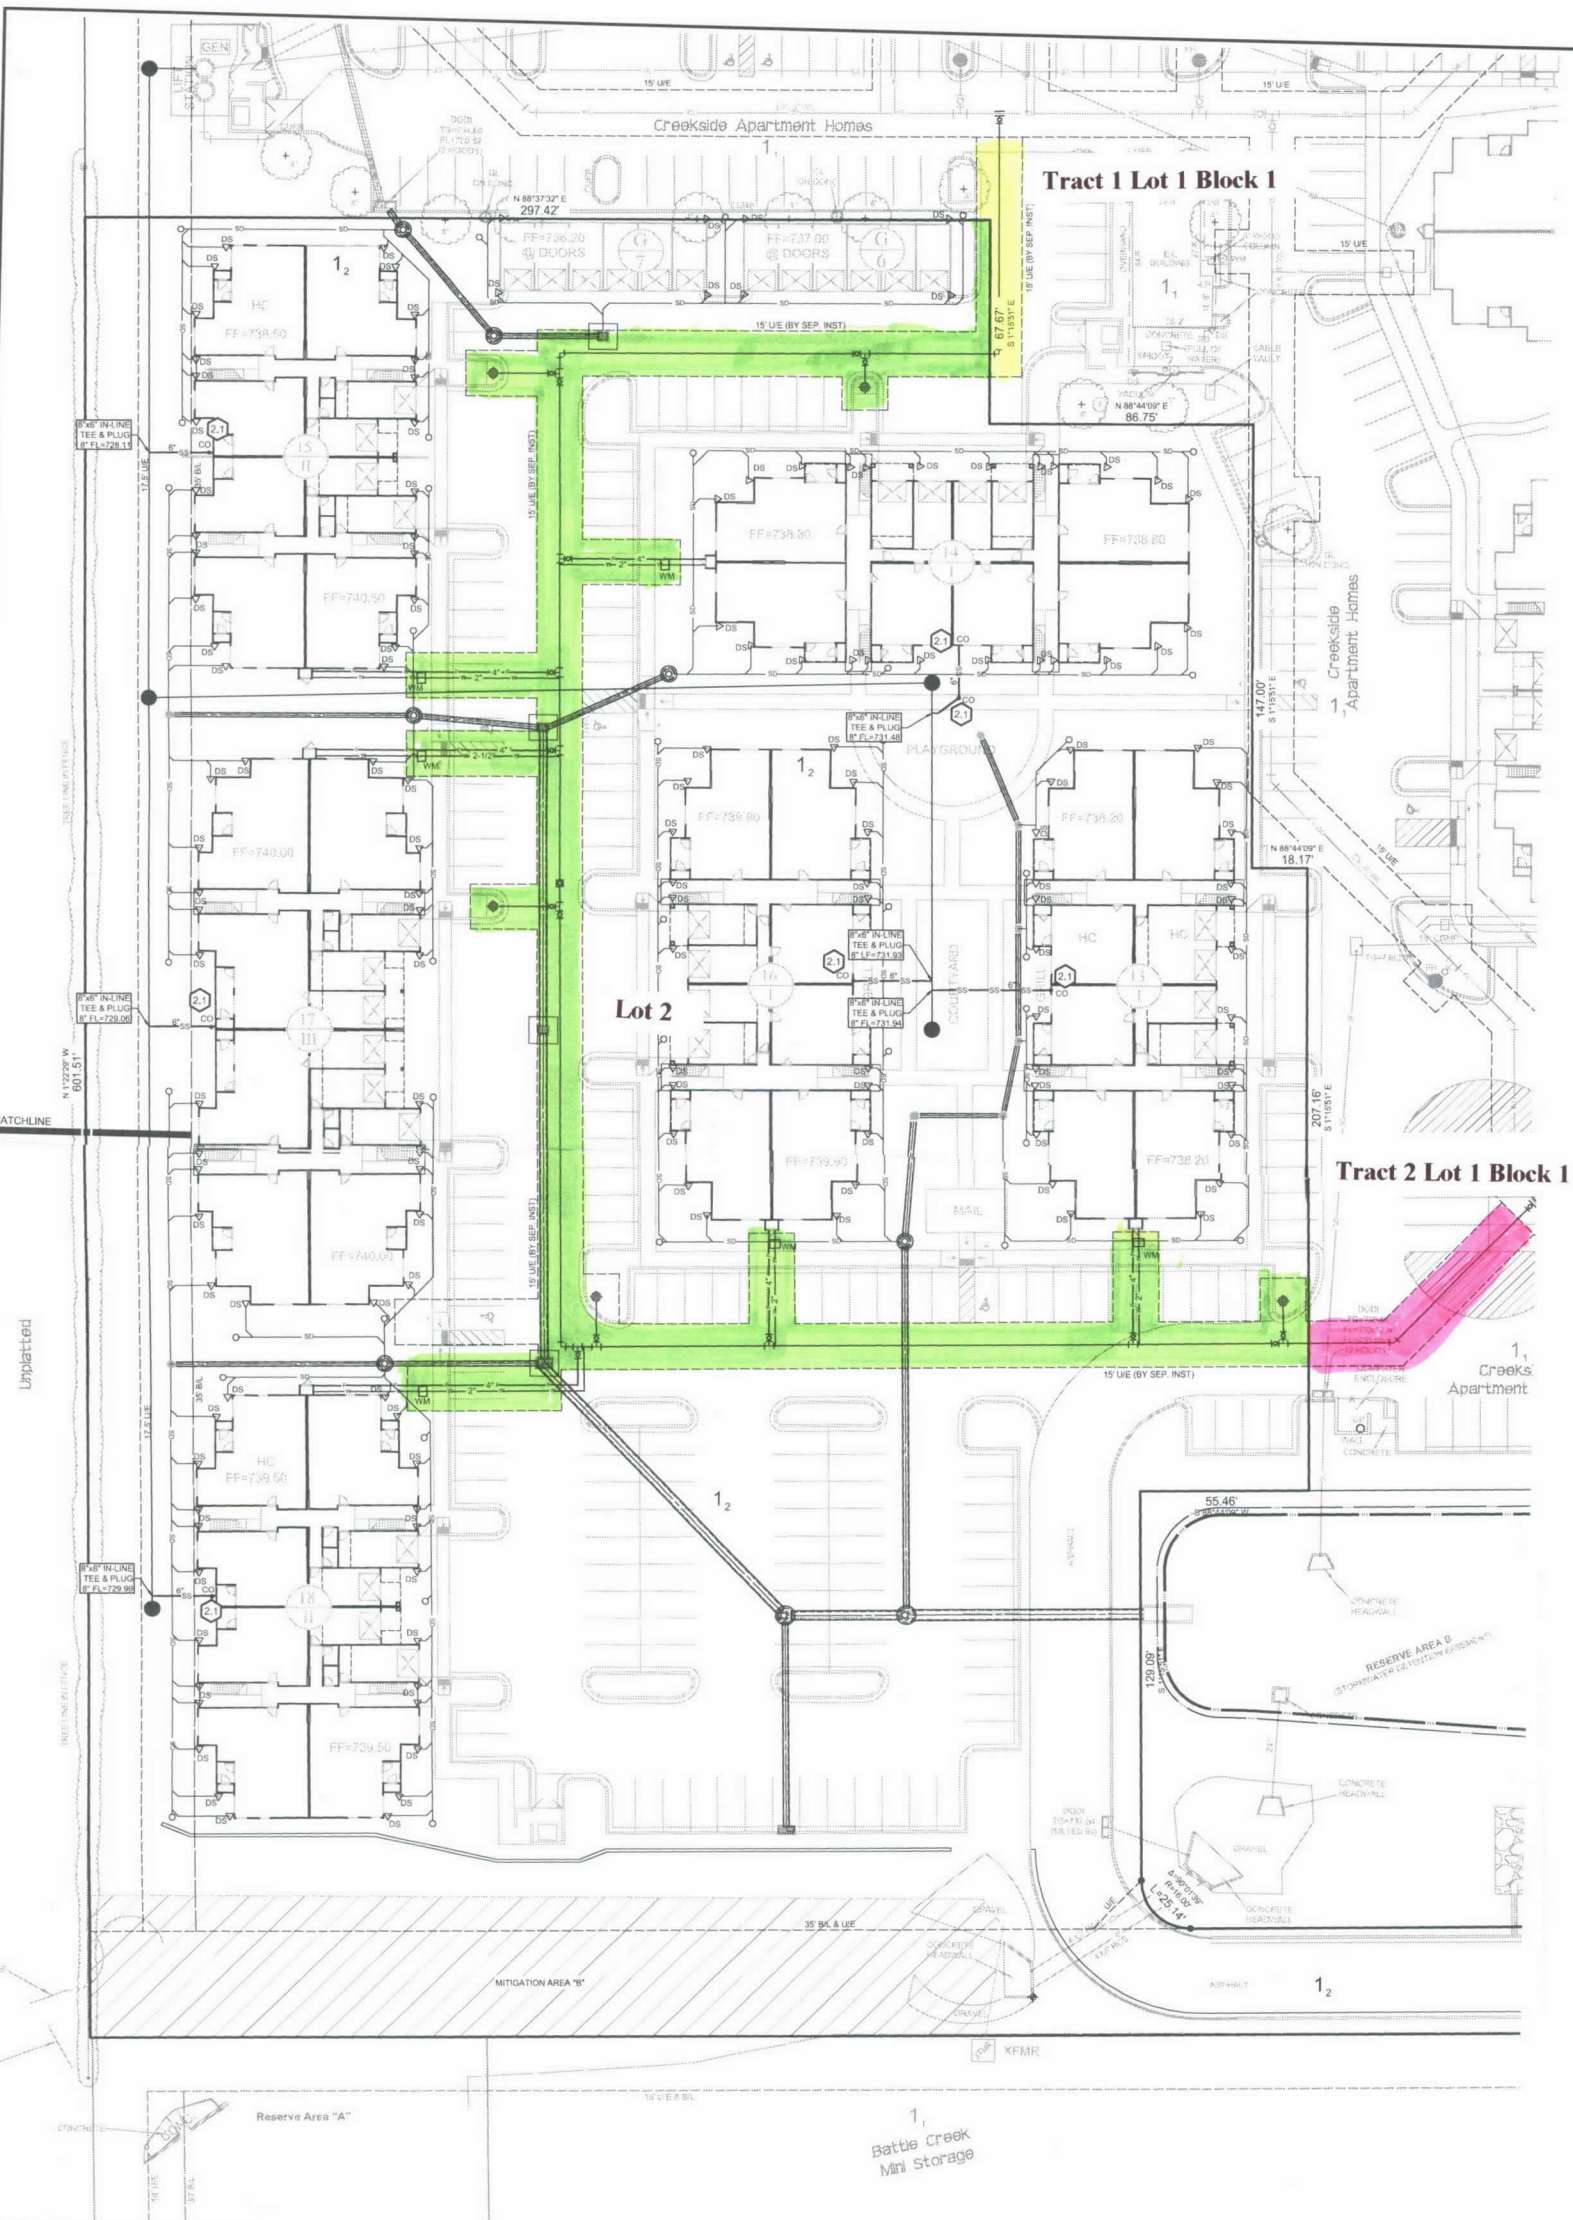

NO.	REVISIONS

ALL CONSTRUCTION TO BE IN STRICT ACCORDANCE WITH CURRENT CITY OF BROKEN ARROW PUBLIC WORKS DEPARTMENT SPECIFICATIONS, INCLUDING C.D.D.T. 2008 EDITION SPECIFICATIONS

88 EAST 30th PLACE  
TULSA, OKLAHOMA 74106  
OKLA. REG. NO. 10000  
PHONE: (918) 485-1800  
FAX: (918) 485-8888  
WWW.SIA-OKLA.COM

**Creekside Apt. Homes-Ph II**  
Utility Plan (S/2)  
(LOTS 1 & 2, BLOCK 1)  
DETENTION DETERMINATION NUMBER: DD-032514-12

STORMWATER DETENTION ACCOMMODATIONS FOR THIS SITE ARE PROVIDED IN ACCORDANCE WITH DETENTION DETERMINATION NO. DD-032514-12.

SCALE	DESIGN	DATE	DRAFTED	DATE
PLAN: 1"=20'	DTW	5/26/17	LAD	5/26/17
HORZ: N/A	REVIEWED	DATE	APPROVED	DATE
VERT: N/A				
DRAWING NAME	SHEET	C14	WORK ORDER NO.	
7141-30UT-PLWG	OF	19	17141.30	

