
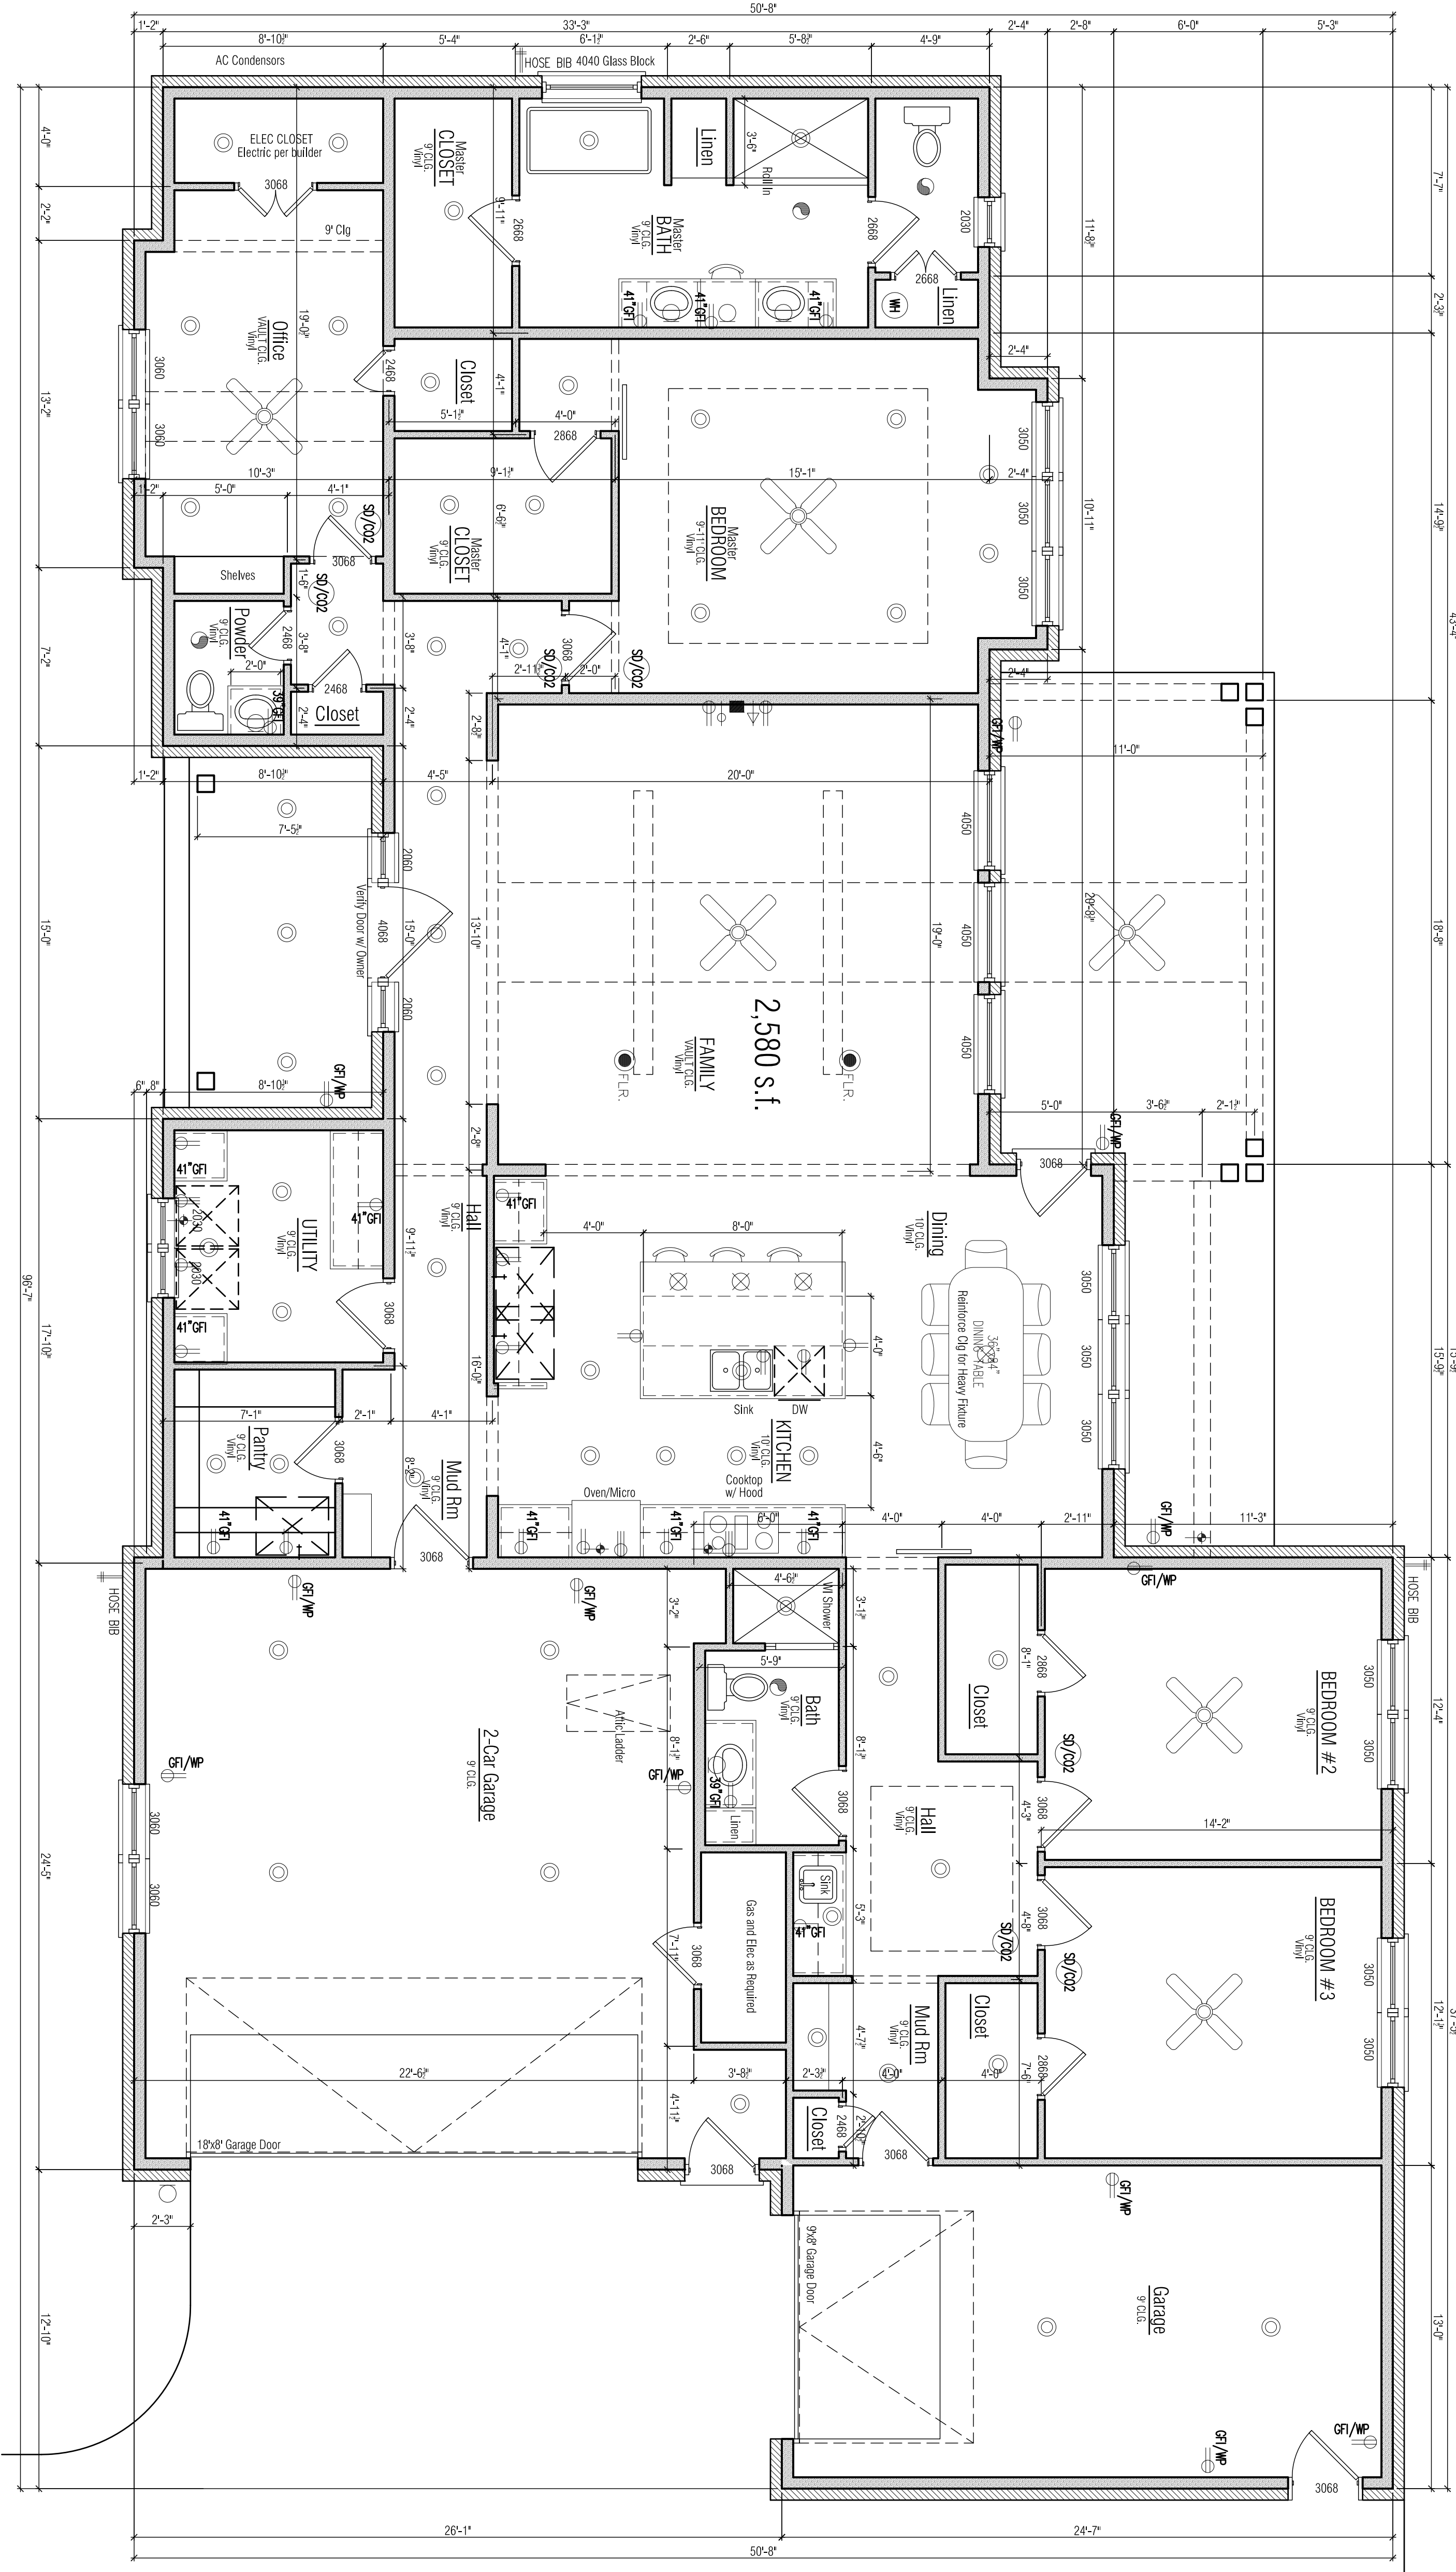


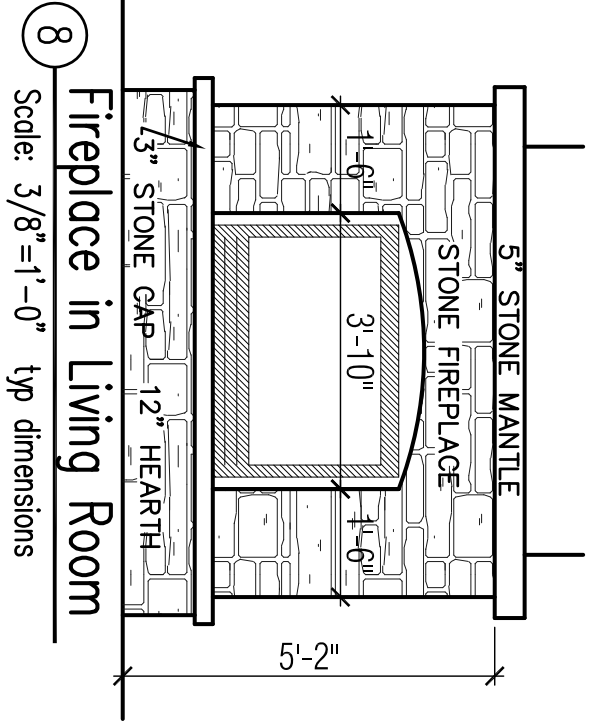

ELECTRICAL LEGEND			
110 VOLT RECEPTACLE	TELEPHONE OUTLET	CHIMNEY	FLOOD LIGHTS
WATERPROOF RECEPTACLE	SINGLE POLE SWITCH	CEILING MOUNTED LIGHT FIXTURE	EXHAUST FAN
110 VOLT IN CLO.	THREE WAY SWITCH	HANGING LIGHT	EXHAUST FAN W/ LIGHT
110 VOLT W/ GROUND FAULT INTERRUPTER	FOUR WAY SWITCH	RECESSED CAN LIGHT	EXHAUST FAN W/ HEAT LAMP
110 VOLT IN FLOOR	10 AMP DIMMER SWITCH	WATERPROOF RECESSED CAN LIGHT	EXHAUST FAN W/ HEAT LAMP & L.T.
220 VOLT RECEPTACLE	RESET BUTTON	RECESSED CROWN LIGHT	WIRELESS CEILING MOUNTED LIGHT FIXTURE
TELEVISION ANTENNA	SMOKE DETECTOR	WALL MOUNTED LIGHT FIXTURE	ZONE SENSOR
DATA OUTLET	INTERCOM	PORCELAIN FINISH W/ PAUL CORO	LOSS CONNECTION (CONSISTS OF 2-ROD & 1 CAT 5)
HOSE BIB	CONDUIT		
SPEAKER PRC. WING	VOLUME CONTROL	INDIC. FAN LOCATION	SUB. WATER LOCATION

1 Architectural First Floor Plan

Scale: 1/4"=1'-0"

Square Footage: 2,580 s.f.

Finished 1st Floor—Over Frame

Designed and Drawn By:	Kenny W Martin	
KWM Phone & Fax 2021	Pad App All Rights Reserved	918.381.6332

Project For:

Hechinger Custom

Foxboro Lot 3 Block 1

7911 S Juniper Place, BA 0k

Builder:

Date: 10-20-2021

Rev:

Builder To Check	Initial
Site Plan, Sections & Plan Dimensions on Lot	
Plan Dimensions	
Roof Plan & Slope	
Doors & Roof Clips	
Wood Materials	
Paint Colors	
Window Sizes	
Finish Locations	

A-201