


FILE LOCATION: P:\1814\2_QuikTrip_0034\01-0034_Quad.dwg TAB NAME: SITE PLAN USER: TECH05 SAVED: 8/14/2015 9:51 AM PLOTTED: 8/14/2015 9:56 AM

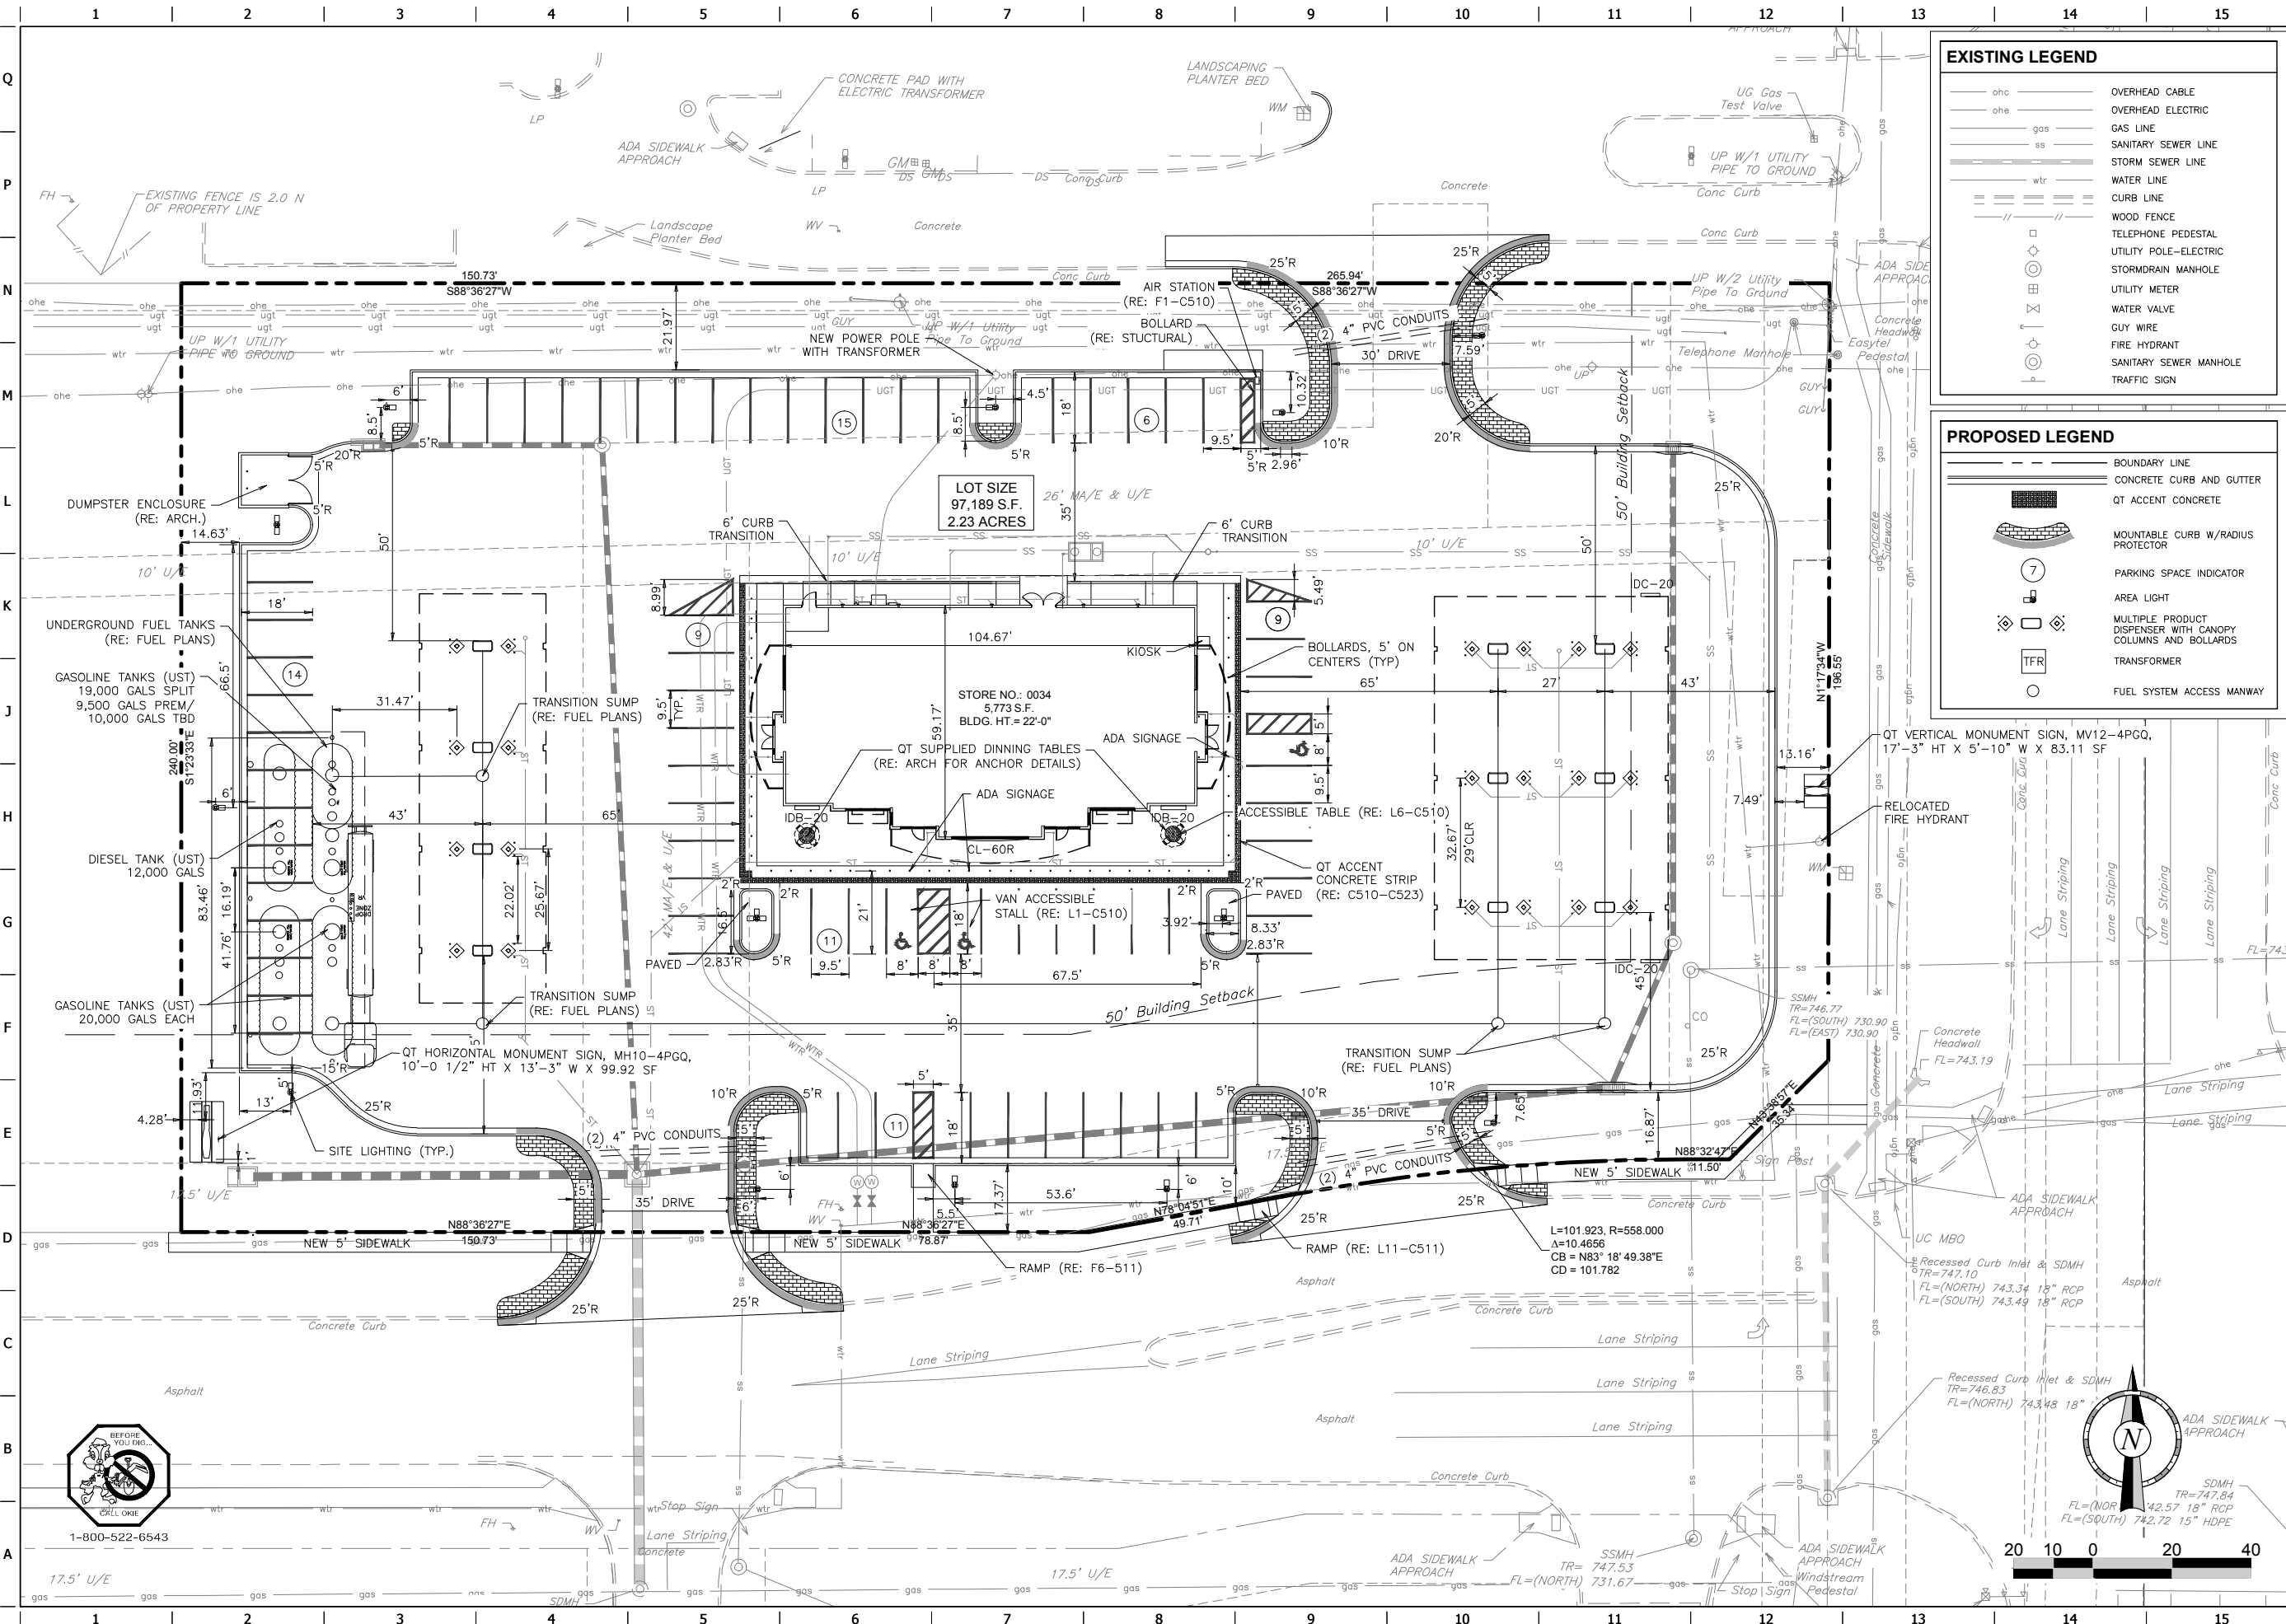

EXISTING LEGEND

ohc	OVERHEAD CABLE
ohe	OVERHEAD ELECTRIC
gas	GAS LINE
ss	SANITARY SEWER LINE
wtr	WATER LINE
---	CURB LINE
---	WOOD FENCE
□	TELEPHONE PEDESTAL
○	UTILITY POLE-ELECTRIC
○	STORM DRAIN MANHOLE
○	UTILITY METER
○	WATER VALVE
○	GUY WIRE
○	FIRE HYDRANT
○	SANITARY SEWER MANHOLE
○	TRAFFIC SIGN

PROPOSED LEGEND

---	BOUNDARY LINE
---	CONCRETE CURB AND GUTTER
□	QT ACCENT CONCRETE
□	MOUNTABLE CURB W/RADIUS PROTECTOR
○	PARKING SPACE INDICATOR
○	AREA LIGHT
□	MULTIPLE PRODUCT DISPENSER WITH CANOPY COLUMNS AND BOLLARDS
□	TRANSFORMER
○	FUEL SYSTEM ACCESS MANWAY

NOTARION
CONSTRUCTION
License No. 25330
THIS DOCUMENT IS PRELIMINARY AND DOES NOT CONSTITUTE A FINAL SIGNED AND SEALED DOCUMENT.

PROJECT NO.: #000000

AAB Engineering, LLC
AAB
Engineering • Surveying
P.O. Box 2136 / 17 E 2nd St.
Sand Springs, OK 74063
OK CA#6318 Exp. June 30, 2016
Office: (918) 514-4263
Fax: (918) 514-4268

QuikTrip No. 0034
S. LYNN LANE RD. AND HILLSIDE DRIVE
BROKEN ARROW, OKLAHOMA

© COPYRIGHT QUIKTRIP CORPORATION 2011
ANY UNAUTHORIZED USE, REPRODUCTION,
PUBLICATION, DISTRIBUTION, OR SALE IN
WHOLE OR IN PART, IS STRICTLY FORBIDDEN.

PROTOTYPE: P-84 (08/01/15)
DIVISION:
VERSION: 001
DESIGNED BY:
DRAWN BY:
REVIEWED BY:

REV	DATE	DESCRIPTION

ORIGINAL ISSUE DATE:

SHEET TITLE:
SITE PLAN

SHEET NUMBER:
C100