
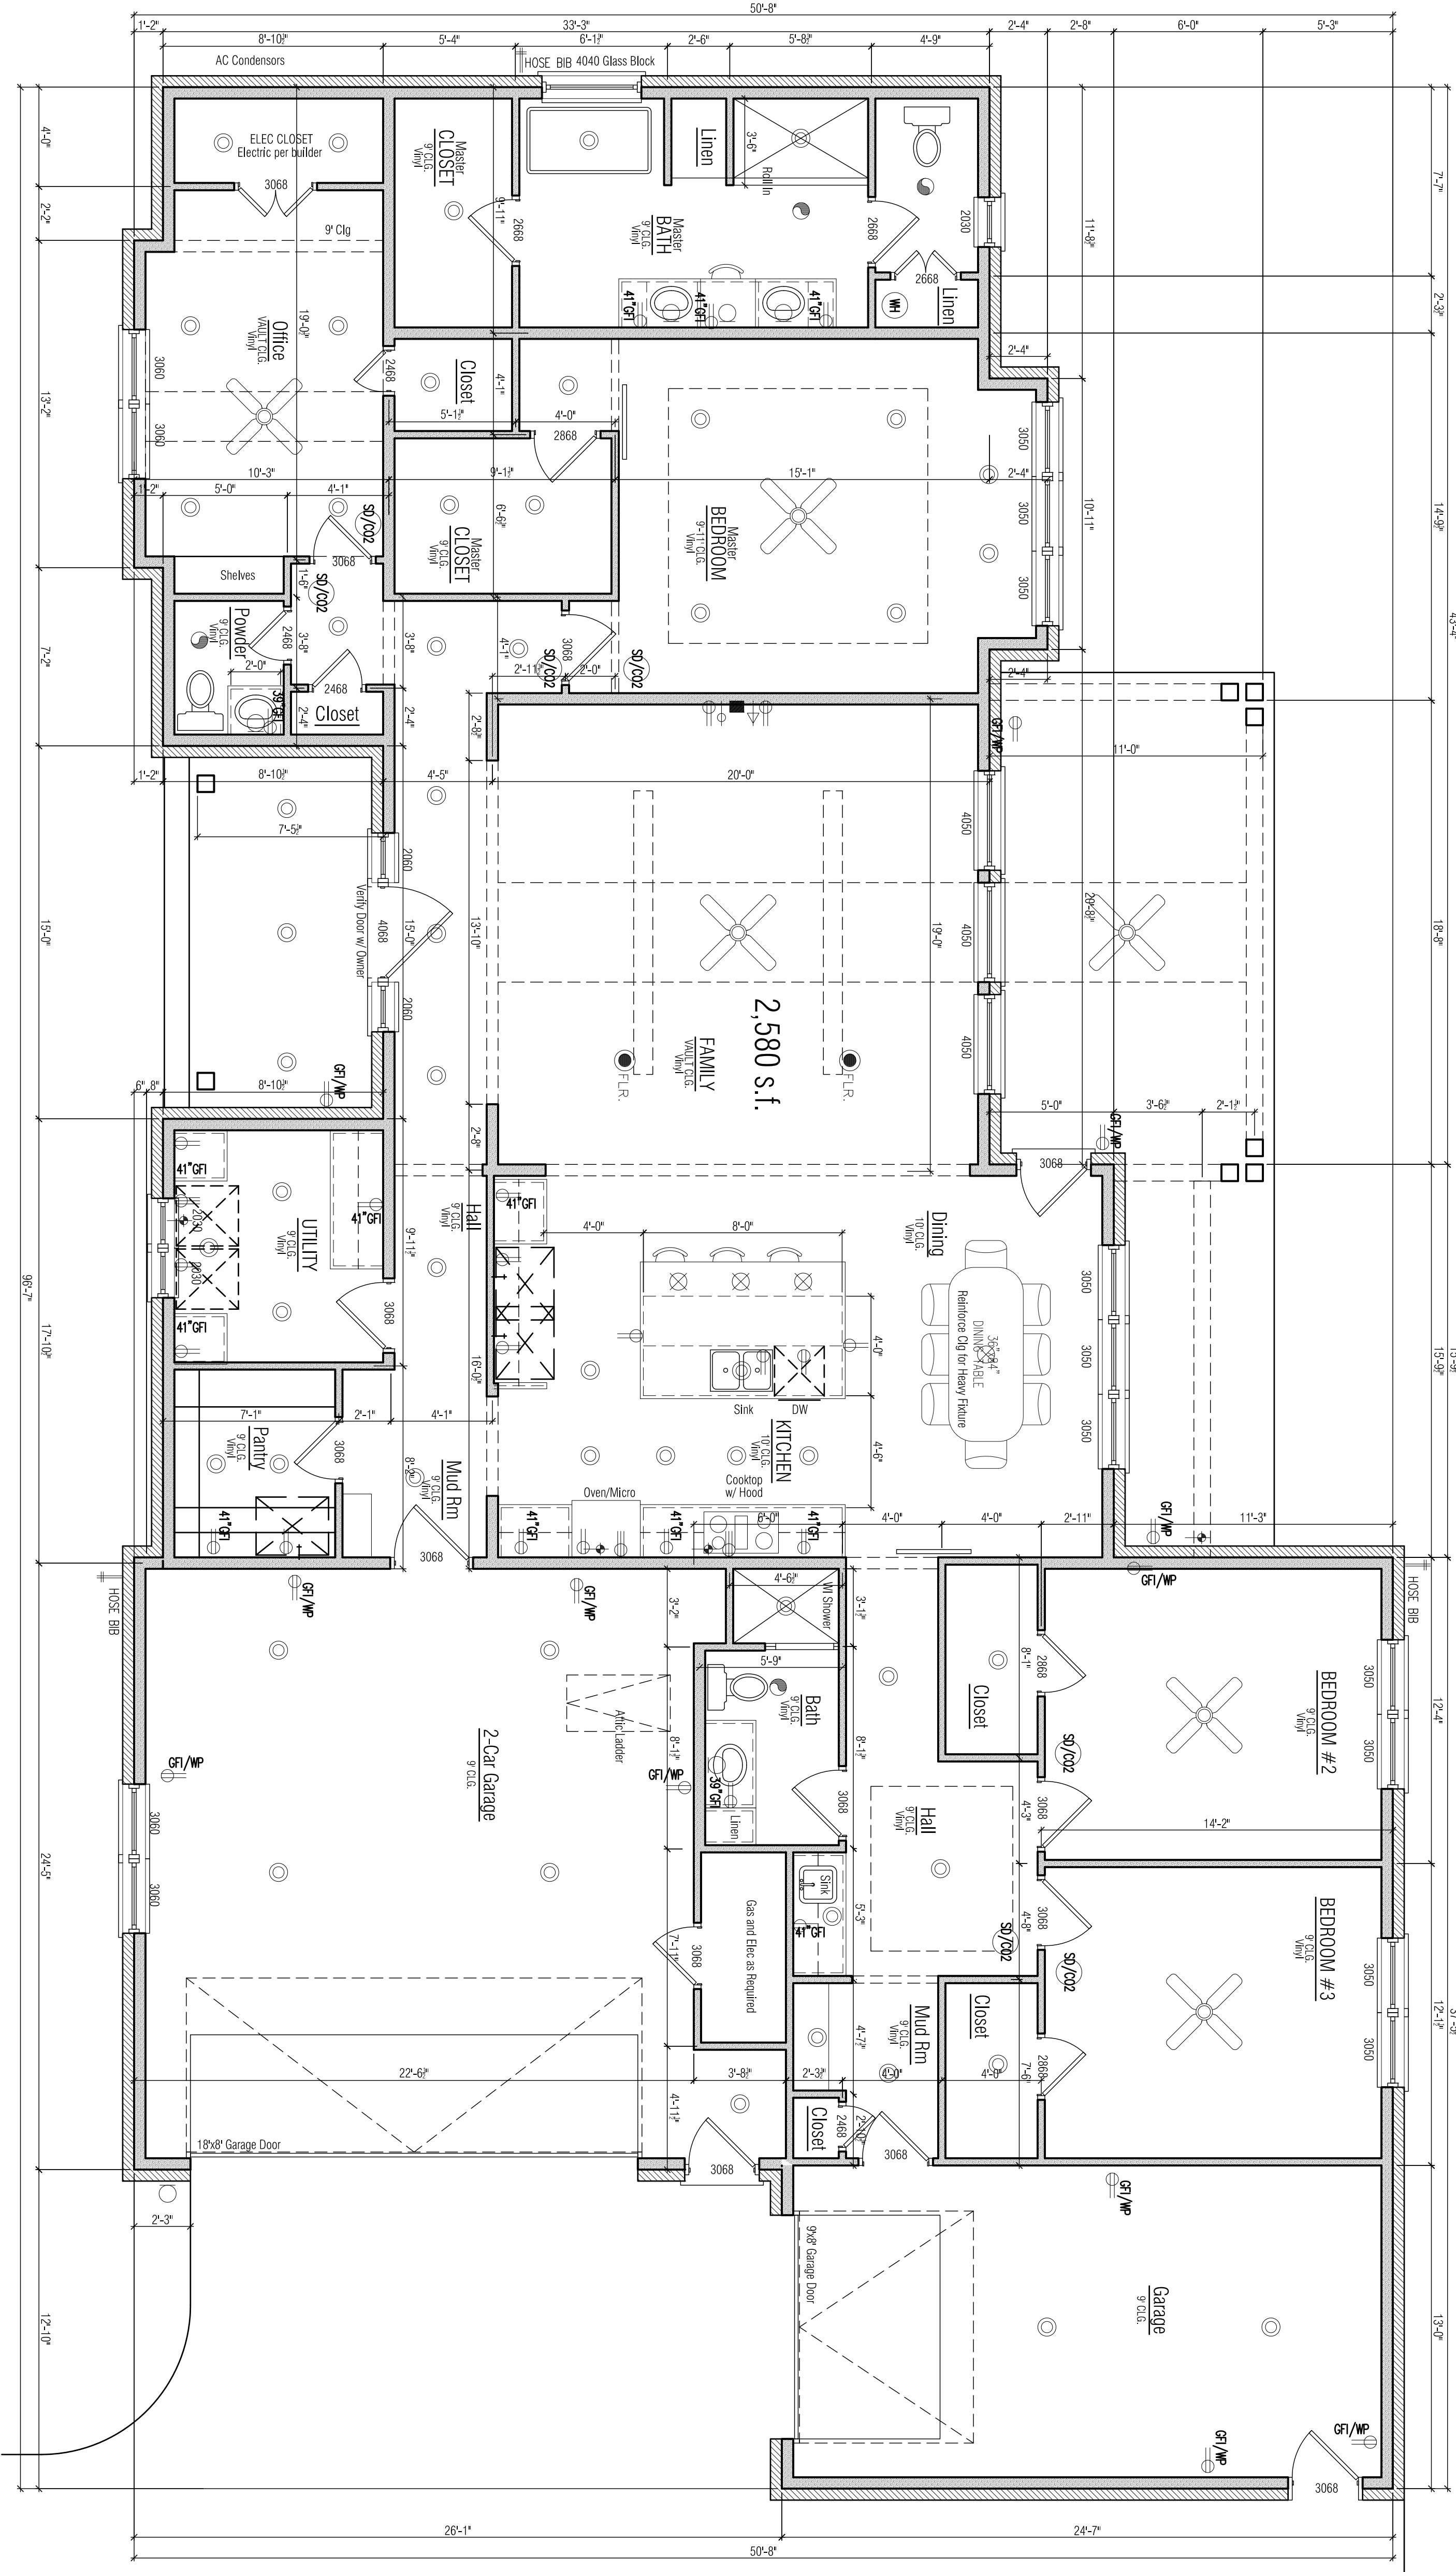


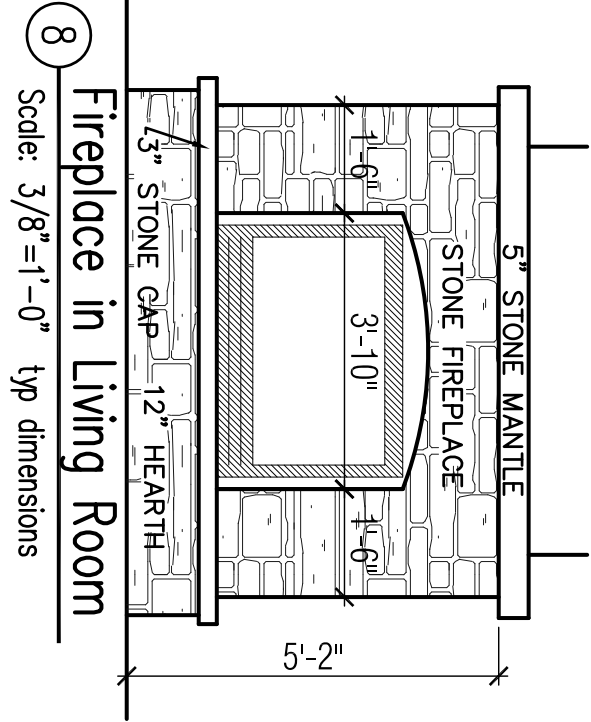

ELECTRICAL LEGEND			
	110 VOLT RECEPTACLE		TELEPHONE OUTLET
	WATERPROOF RECEPTACLE		SINGLE POLE SWITCH
	110 VOLT IN CLO.		THREE WAY SWITCH
	110 VOLT W/ GROUND FAULT INTERRUPTER		FAN WAY SWITCH
	110 VOLT IN FLOOR		DIMMER SWITCH
	220 VOLT RECEPTACLE		WATERPROOF RECESSED CAN LIGHT
	TELEVISION ANTENNA		PUSH BUTTON
	GAS OUTLET		RECESSED CROWN LIGHT
	HOSE BIB		WALL MOUNTED LIGHT FIXTURE
	SPEAKER PRC. WING		PORCELAIN FINISH W/ PAUL CORO
	VOLUME CONTROL		THERMOSTAT
	FLOOD LIGHTS		CONDUIT
	CEILING MOUNTED LIGHT FIXTURE		SHOWER LOCATION
	EXHAUST FAN W/ LIGHT		CEILING FAN
	EXHAUST FAN W/ HEAT LAMP		CEILING FAN W/ LIGHT
	EXHAUST FAN W/ HEAT LAMP & L.T.		CEILING LIGHT W/ FIBER OPTIC
	RECESSED CEILING MOUNTED LIGHT FIXTURE		
	ZONE SENSOR		
	OSS CONNECTION (CONSISTS OF 2-400 & 1 CAT 5)		

1 Architectural First Floor Plan

Scale: 1/4"=1'-0"

Square Footage: 2,580 s.f.

Finished 1st Floor—Over Frame

Designed and Drawn By:	Kenny W Martin
KWM Phone & Fax 2021	Pad App All Rights Reserved
	918.381.6332

Project For:

Hechinger Custom

Foxboro Lot 3 Block 1

7911 S Juniper Place, BA 0k

Builder:

Date: 10-20-2021

Rev:

Builder To Check	Initial
Site Plan, Sections & Plan Dimensions on Lot	
Plan Dimensions	
Roof Plan & Slope	
Doors & Floor Clo.	
Wood Materials	
Paint Colors	
Window Sizes	
Finish Locations	