


SYMBOL	DESCRIPTION
	NEW WALL - WOOD STUD
	EXISTING WALL TO REMAIN
	ITEM TO BE DEMOLISHED
	MASONRY VENEER

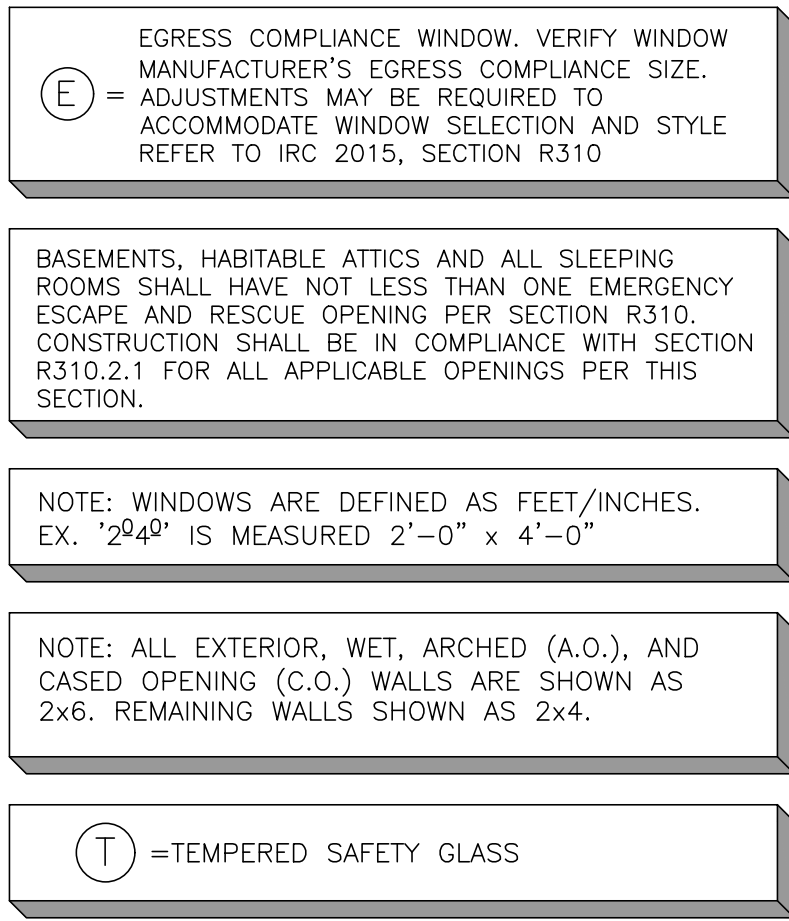

wdesign
ARCHITECTURE & INTERIOR
5 E. 3rd Street, Suite
Tulsa, OK 74120
Office: 918.794.6616
Fax: 918.794.6602
www.wdesignsite.com

AL:



11/8/2017
WELDON BOWMAN, AIA
OK LICENSE NO. 6042
CA# 02461 EXPIRES 06/30/2019

PROJECT:

**BORN AGAIN
RESTORED
ADDITION**

PROJECT #
17173

2 E. COMMERCIAL
BROKEN ARROW C
74012

CONSULTANT:

REVISIONS:

ISSUE DATE:

1.8.2017

FLOOR PLAN
SECOND FLOOR

SHEET #:



A2

ELECTRICAL SCHEDULE		
MARK	DESCRIPTION	REMARKS
Ⓢ	6 3/4" RECESSED CAN W/ STEEP BAFTEL	
Ⓢ	6 3/4" RECESSED CAN W/ WHITE DIFFUSER	FOR WET LOCATION
Ⓢ	6 3/4" RECESSED CAN FOR STEEP SLOPE	30'(7/12) - 45'(12/12)
Ⓢ	4" RECESSED MINI-CAN W/ DIFFUSER	
Ⓢ	PENDANT OR CHANDELIER	REINFORCE FRAMING FOR SECURE INSTALLATION
Ⓢ	SURFACE MOUNTED CEILING FIXTURE	
Ⓢ	KEYLESS - PORCELAIN	NO PULLCHAIN SWITCH
Ⓢ	WALL MOUNTED FIXTURE (INTERIOR)	STUB OUT, NO BOX, REFER TO PLANS FOR HEIGHT
Ⓢ	WALL MOUNTED FIXTURE (EXTERIOR)	STUB OUT, NO BOX, REFER TO PLANS FOR HEIGHT
Ⓢ	SURFACE MOUNTED FLUORESCENT CEILING FIXTURE	
Ⓢ	UNDER COUNTER LIGHT	
Ⓢ	FLOOD LIGHTS	
Ⓢ	CEILING FAN WITH LIGHT	REINFORCE FRAMING FOR SECURE INSTALLATION
Ⓢ	HEAT FAN/EXHAUST FAN/LIGHT	DUCT TO OUTSIDE .50 CFM INTERMITTENT
Ⓢ	LIGHT /EXHAUST FAN	DUCT TO OUTSIDE .50 CFM INTERMITTENT
Ⓢ	EXHAUST FAN	DUCT TO OUTSIDE .50 CFM INTERMITTENT
Ⓢ	SWITCH	2 = 2 POLE, 3 = 3-WAY & 4 = 4-WAY
Ⓢ	GARAGE DOOR BUTTON OR PUSH BUTTON TYPE SWITCH	
Ⓢ	120 V. FLOOR OUTLET	REFER TO PLAN FOR SPECIAL LOCATIONS
Ⓢ	TELEVISION RECEPT. (RECESSED OUTLET)	
Ⓢ	TELEPHONE OUTLET	
Ⓢ	CABLE TELEVISION OUTLET	
Ⓢ	SMOKE DETECTOR	
Ⓢ	CARBON MONOXIDE DETECTOR	
Ⓢ	GARAGE DOOR OPENER	
Ⓢ	AIR CONDITIONER CONDENSER	
Ⓢ	FURNACE (FORCED AIR UNIT)	VERIFY IF GAS OR ELECTRIC
Ⓢ	WATER HEATER	VERIFY IF GAS OR ELECTRIC
Ⓢ	TANKLESS WATER HEATER	VERIFY IF GAS OR ELECTRIC

ELECTRICAL NOTES:


- ELECTRICIAN TO PROVIDE POWER SUPPLY TO ALL APPLIANCES WHETHER INDICATED OR NOT. (i.e. DISHWASHER, DISPOSAL, ICE MAKER, etc.)
- ELECTRICIAN TO VERIFY POWER REQUIRED FOR COOKTOP AND OVENS - GAS OR ELECTRIC.
- OUTLETS LOCATED ABOVE COUNTERTOPS ARE CENTERED 8" ABOVE COUNTERTOP SURFACE. CONSULT OWNER FOR COUNTERTOPS HEIGHTS.
- LOCATE SMOKE DETECTORS AND THERMOSTATS NEAR RETURN AIR GRILLES AND PER LOCAL CODE REQUIREMENTS. CONSULT MECHANICAL CONTRACTOR.
- VERIFY LOCATION OF ALL FLOOR OUTLETS WITH OWNER PRIOR TO INSTALLATION.
- ALL FINISHES SUBJECT TO OWNER'S APPROVAL.
- LAMPS INSTALLED SHOULD NOT EXCEED MANUFACTURER RECOMMENDED WATTAGE.
- ELECTRICAL LAYOUT IS SCHEMATIC IN DESIGN AND SHALL BE THE RESPONSIBILITY OF THE GENERAL CONTRACTOR, ELECTRICAL CONTRACTOR AND OWNER FOR FINAL SELECTION OF FIXTURES AND LAYOUT.

NOTE: ADD 5-6 LIGHTS IN CRAWLSPACE WITH SWITCH Ⓢ ENTRY LOCATION

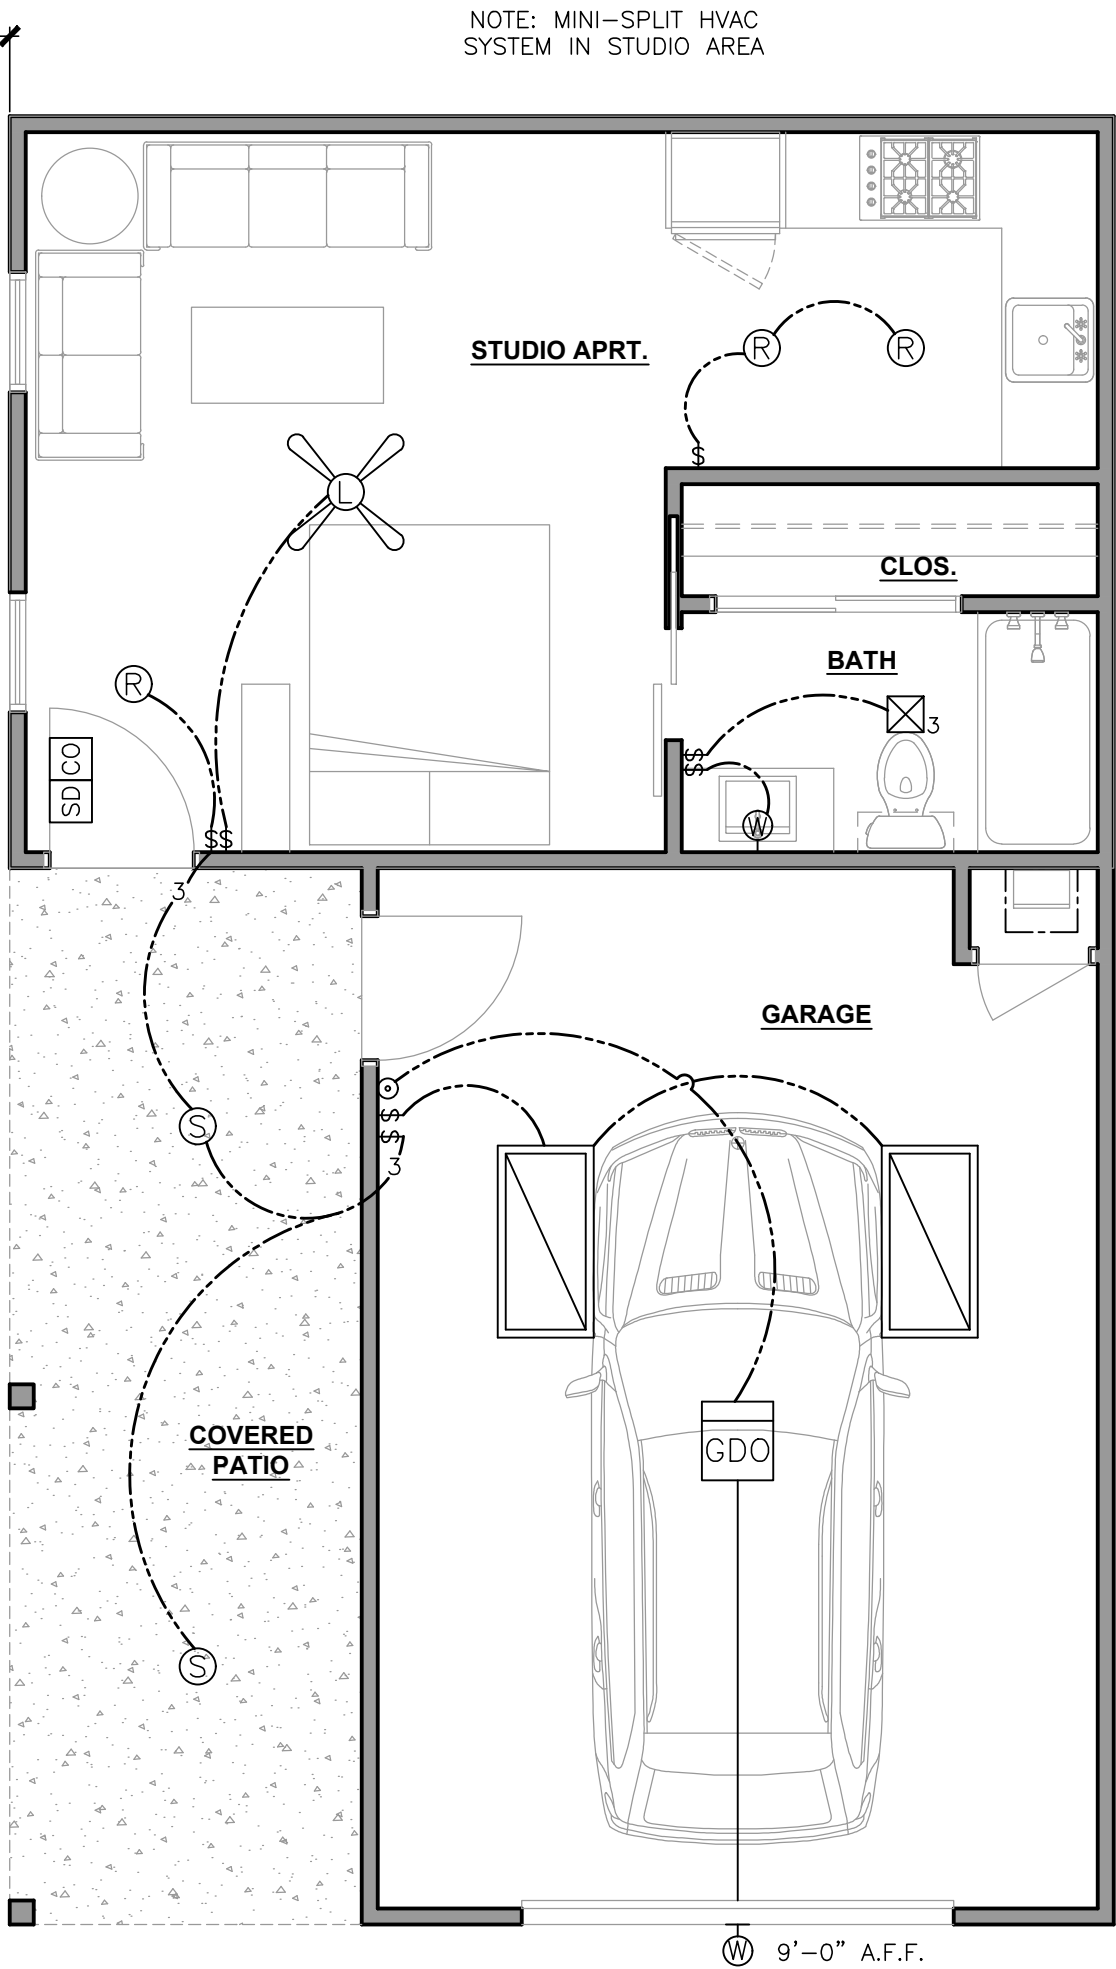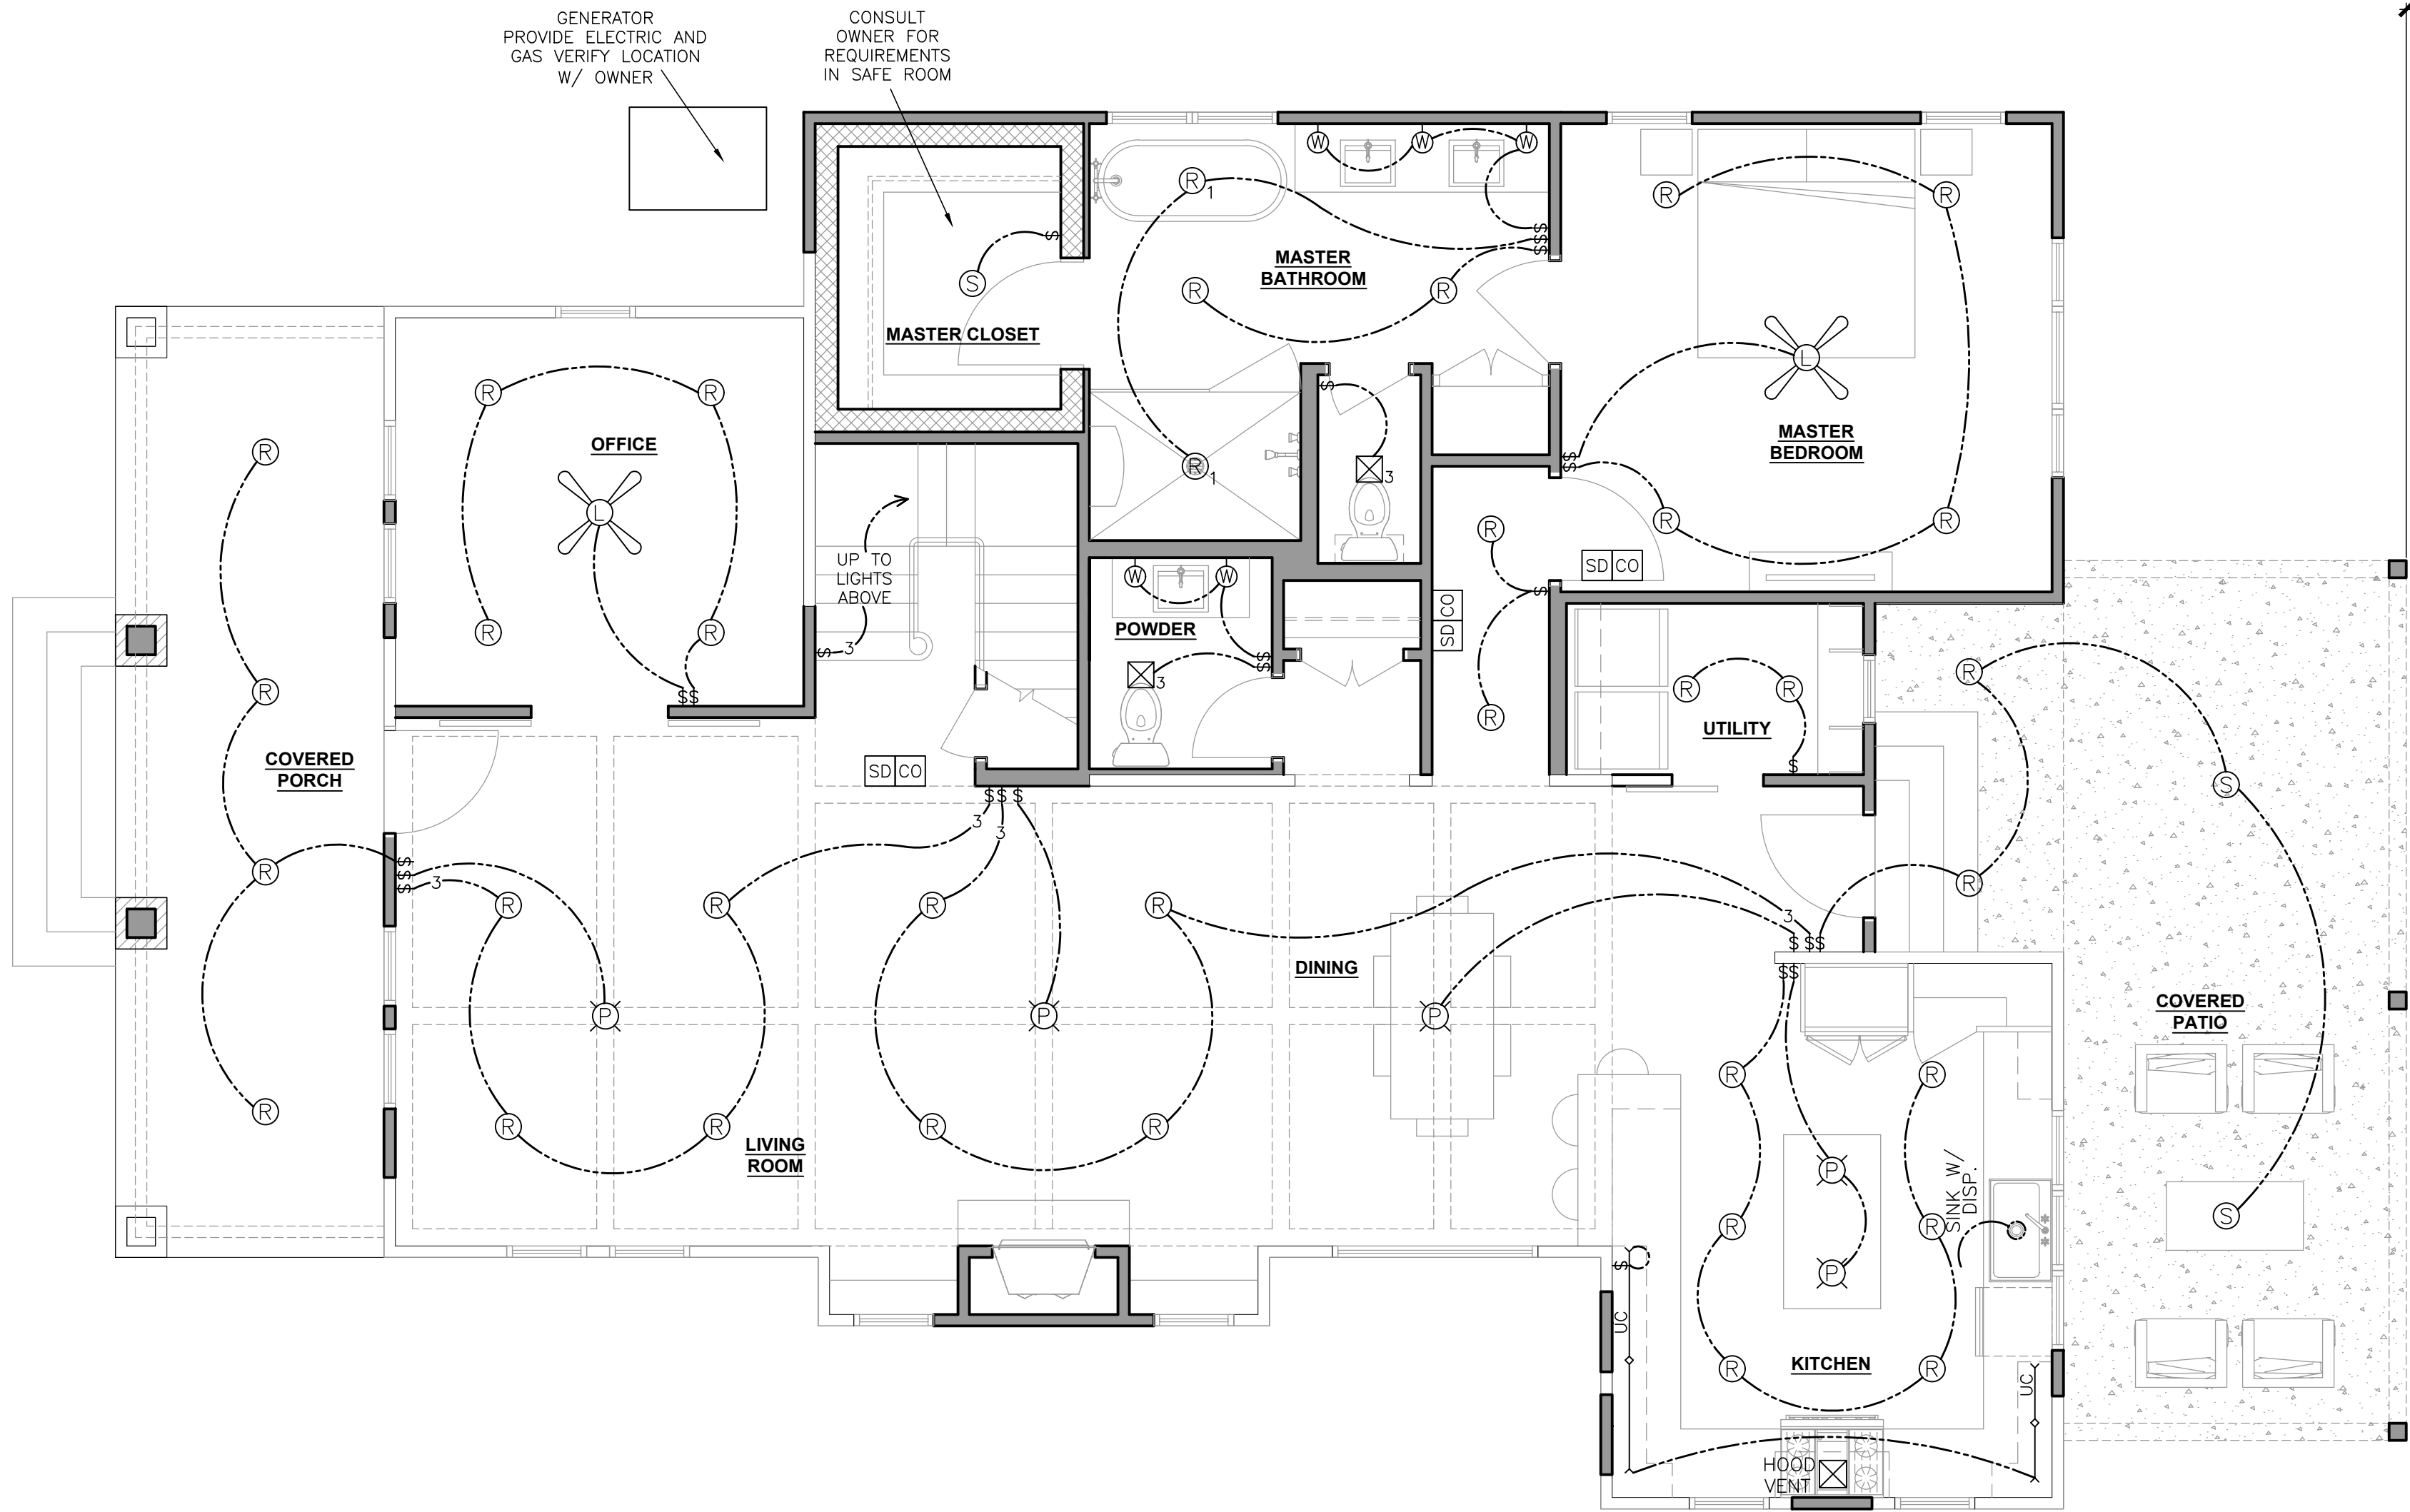

1 LIGHTING PLAN - FIRST FLOOR

SCALE: 1/4" = 1'-0"

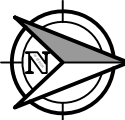

ARCHITECTURE & INTERIORS
815 E. 3rd Street, Suite C
Tulsa, OK 74120
Office: 918.794.6616
Fax: 918.794.6602
www.wdesignsite.com

SEAL:



11/8/2017
WELDON BOWMAN, AIA
OK LICENSE NO. 6042
CA# 02461 EXPIRES 06/30/2019

PROJECT:

BORN AGAIN
RESTORED
ADDITION

PROJECT #
17173

232 E. COMMERCIAL ST.
BROKEN ARROW OK.
74012

CONSULTANT:

REVISIONS:

ISSUE DATE:

11.8.2017

SHEET NAME:
LIGHTING PLAN -
FIRST FLOOR


SHEET #:

E1

ELECTRICAL SCHEDULE		
MARK	DESCRIPTION	REMARKS
Ⓢ	6 3/4" RECESSED CAN W/ STEEL BACKPLATE	
Ⓢ	6 3/4" RECESSED CAN W/ WHITE DIFFUSER	FOR WET LOCATION
Ⓢ	6 3/4" RECESSED CAN FOR STEEP SLOPE	30'(7/12) - 45'(12/12)
Ⓢ	4" RECESSED MINI-CAN W/ DIFFUSER	
Ⓢ	PENDANT OR CHANDELIER	REINFORCE FRAMING FOR SECURE INSTALLATION
Ⓢ	SURFACE MOUNTED CEILING FIXTURE	
Ⓢ	KEYLESS - PORCELAIN	NO PULLCHAIN SWITCH
Ⓢ	WALL MOUNTED FIXTURE (INTERIOR)	STUB OUT, NO BOX, REFER TO PLANS FOR HEIGHT
Ⓢ	WALL MOUNTED FIXTURE (EXTERIOR)	STUB OUT, NO BOX, REFER TO PLANS FOR HEIGHT
Ⓢ	SURFACE MOUNTED FLUORESCENT CEILING FIXTURE	
Ⓢ	UNDER COUNTER LIGHT	
Ⓢ	FLOOD LIGHTS	
Ⓢ	CEILING FAN WITH LIGHT	REINFORCE FRAMING FOR SECURE INSTALLATION
Ⓢ	HEAT FAN/EXHAUST FAN/LIGHT	DUCT TO OUTSIDE .50 CFM INTERMITTENT
Ⓢ	LIGHT /EXHAUST FAN	DUCT TO OUTSIDE .50 CFM INTERMITTENT
Ⓢ	EXHAUST FAN	DUCT TO OUTSIDE .50 CFM INTERMITTENT
Ⓢ	SWITCH	2 = 2 POLE, 3 = 3-WAY & 4 = 4-WAY
Ⓢ	GARAGE DOOR BUTTON OR PUSH BUTTON TYPE SWITCH	
Ⓢ	120 V. FLOOR OUTLET	REFER TO PLAN FOR SPECIAL LOCATIONS
Ⓢ	TELEVISION RECEPT. (RECESSED OUTLET)	
Ⓢ	TELEPHONE OUTLET	
Ⓢ	CABLE TELEVISION OUTLET	
Ⓢ	SMOKE DETECTOR	
Ⓢ	CARBON MONOXIDE DETECTOR	
Ⓢ	GARAGE DOOR OPENER	
Ⓢ	AIR CONDITIONER CONDENSER	
Ⓢ	FURNACE (FORCED AIR UNIT)	VERIFY IF GAS OR ELECTRIC
Ⓢ	WATER HEATER	VERIFY IF GAS OR ELECTRIC
Ⓢ	TANKLESS WATER HEATER	VERIFY IF GAS OR ELECTRIC

ELECTRICAL NOTES:

- ELECTRICIAN TO PROVIDE POWER SUPPLY TO ALL APPLIANCES WHETHER INDICATED OR NOT. (i.e. DISHWASHER, DISPOSAL, ICE MAKER, etc.)
- ELECTRICIAN TO VERIFY POWER REQUIRED FOR COOKTOP AND OVENS - GAS OR ELECTRIC.
- OUTLETS LOCATED ABOVE COUNTERTOPS ARE CENTERED 8" ABOVE COUNTERTOP SURFACE. CONSULT OWNER FOR COUNTERTOPS HEIGHTS.
- LOCATE SMOKE DETECTORS AND THERMOSTATS NEAR RETURN AIR GRILLES AND PER LOCAL CODE REQUIREMENTS. CONSULT MECHANICAL CONTRACTOR.
- VERIFY LOCATION OF ALL FLOOR OUTLETS WITH OWNER PRIOR TO INSTALLATION.
- ALL FINISHES SUBJECT TO OWNER'S APPROVAL.
- LAMPS INSTALLED SHOULD NOT EXCEED MANUFACTURER RECOMMENDED WATTAGE.
- ELECTRICAL LAYOUT IS SCHEMATIC IN DESIGN AND SHALL BE THE RESPONSIBILITY OF THE GENERAL CONTRACTOR, ELECTRICAL CONTRACTOR AND OWNER FOR FINAL SELECTION OF FIXTURES AND LAYOUT.

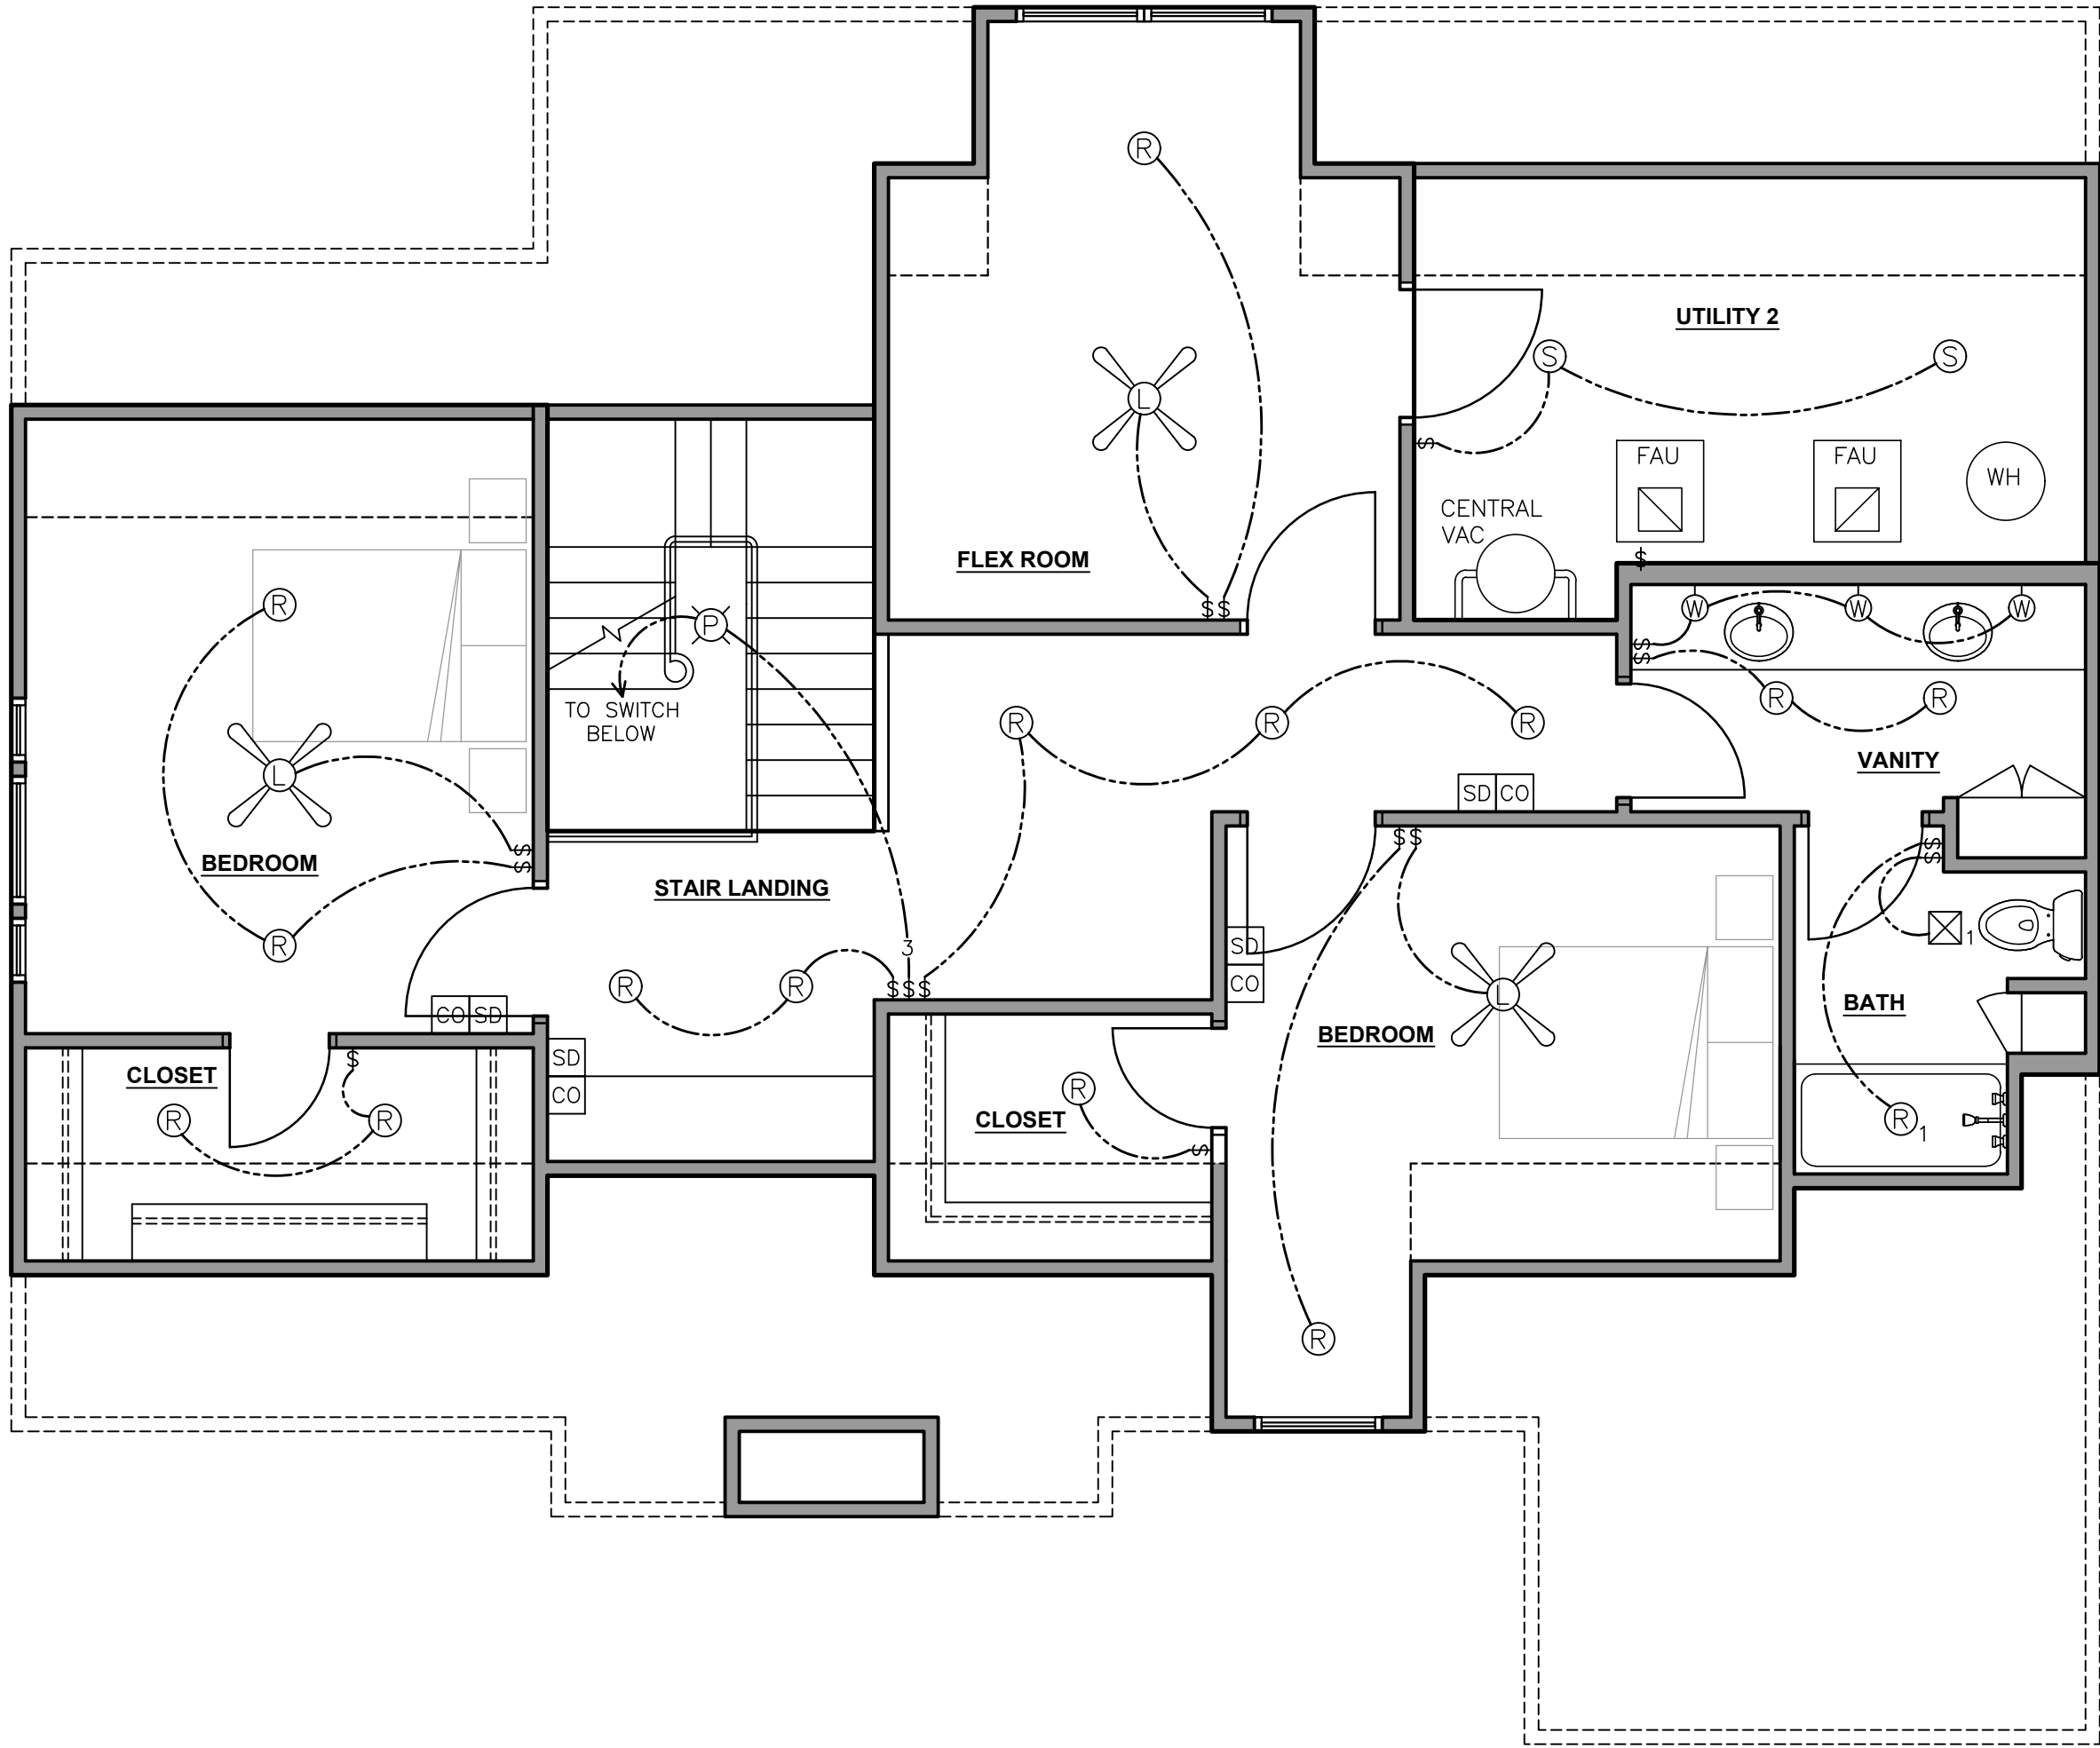


1 LIGHTING PLAN - SECOND FLOOR
SCALE: 1/4" = 1'-0"



ARCHITECTURE & INTERIORS
815 E. 3rd Street, Suite C
Tulsa, OK 74120
Office: 918.794.6616
Fax: 918.794.6602
www.wdesignsite.com

SEAL:

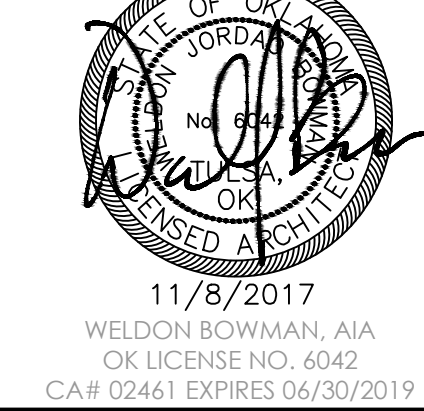

PROJECT:

BORN AGAIN
RESTORED
ADDITION

PROJECT #
17173

232 E. COMMERCIAL ST.
BROKEN ARROW OK.
74012

CONSULTANT:

REVISIONS:

ISSUE DATE:

11.8.2017

SHEET NAME:
LIGHTING PLAN -
SECOND FLOOR

SHEET #:

E2